

Lake County Emergency Telephone System Board

Action Item for Consideration on October 3, 2023

Consolidated PSAP Xybix Dispatch Console Purchase

It is proposed:

Motion to approve purchase of 34 primary dispatch consoles in the amount of \$823,203.44, 6 backup dispatch consoles in the amount of \$45,067.30, and installation services from Xybix Systems Inc. Littleton, CO for a total amount not to exceed \$868,270.74 budget line 85070.

Background:

Lake County ETSB in partnership and support of the consolidated PSAP at the ROC Facility and future consolidated dispatch operation is providing technology and support that will enable the processing and dispatch of emergency calls for service in a timely manner in a new consolidated PSAP.

Rationale:

Xybix has proposed complete dispatch console furniture designs for 34 primary dispatch consoles and 6 backup consoles that were created with input from consolidation PSAP partners and ROC facility teams. The layout and configuration of each console has been completed with operational needs and comfort as a priority for the telecommunicators that will be operating from the consoles daily. Xybix was chosen through a scoring process that included site visits and demonstrations with two major dispatch furniture manufacturers. Xybix stands out with their innovative designs and modular components that allowed for customization to best meet the requirements of the consolidated PSAP operation.

Timeliness:

Execution upon approval pending transfer of reserve funds.

Budget Impact:

\$868,270.74, budget line 84070.

Section A – Relevant Experience & References

- Identify furniture manufacturer, dealer/distributor alignment, and overview of manufacture capacity, capability, and annual volume.
- Provide a contract profile sheet for up to five similar contractual agreements per the scope of services and value add requests previously described. Emphasis should be placed on agreements still in effect or recently completed with government agencies.
- Provide contact information for the reference’s projects for Lake County inquiry and discussion.

Section B – Project Design and Management Team

- List specific personnel (including sub consultants) proposed for the project team, including the project assignment and role or area of responsibility of each individual.
- In the event that this contact leaves the employment of this firm, who will replace this position (provide full background for this individual for consideration)?

Section C – Qualitative Analysis

Lake County will conduct a comparative analysis of the Proposer’s product offering, based upon the typical use scenarios as identified in this section. Proposer shall include quantity of products applicable to design and shall include catalog, brochure, or cut sheets as necessary to clearly articulate the products utilized in the scenario. Products must be singular identifiable components (as compared to a product “line”). All products shall be manufacturer’s core line of finishes/details/options

Section D – Quantitative Analysis

Provide outfitted dispatch center pricing based on Lake County accessible joint purchasing agreement. Provide per unit and per component breakouts as requested by Lake County to conduct this evaluation.

Section E – Firm Differentiation

Please respond to the individual questions carefully and succinctly.

- Provide a detailed description of your design approach to this project, which demonstrates your understanding of specific, critical issues and challenges pertaining to the design and construction of a project of this nature.
- Provide a description of the attributes, processes and/or experiences that differentiates your firm from other firms.
- Describe the most innovative relevant project undertaken by your firm in the last five years and how it impacted the building users/owner.
- Describe your firm’s familiarity with applicable codes and regulations, ergonomics, industry trends, and best practices.

Section F - Value Added Services

Lake County considers Value Added Services to be additional services, certain specific business procedures, quality features, methods or additional business activities offered by the Proposer that when utilized directly or indirectly serve to increase the total value of the services proposed. Lake County invites Proposers to include Value Added Services by attaching additional pages. Proposers Value-Added Services must identify any potential costs associated with these services.

Evaluation Factors:

- Relevant Experience:** Proven experience in the implementation of similar contractual relationships;
- Project Team:** Qualifications of proposed project team members, including depth of talent and staffing experienced in the execution of similar contracts;
- Qualitative Analysis:** Product offering, compatibility, and quality;
- Quantitative Analysis:** Pricing structure
- Meets or Exceeds scope of work:** Service inclusions, customer interface, and project management
- Firm Differentiation:** Distinct attributes that make the firm uniquely capable to provide the services required and value-added services.

Xybix Systems, Inc.
 8207 SouthPark Circle
 Littleton CO 80120
 Phone: 303-683-5656
 Fax: 303-683-5454
 meghand



Quote Number: 31923

Quote Date: 9/20/2023
 Revision: D
 Orig Create Date: 9/18/2023
 Expires: 12/17/2023
 Opp #: 0026249

Quote

Terms: NET 30

Page: 1 of 6

<p>QUOTE TO: Acct: LAKCOULIL</p> <p>Lake County 911 Dispatch Center 18 N County Street 8th Floor Waukegan IL 60048</p> <p>Phone: Email:</p>	<p>SHIP TO: Lake County 911 Dispatch Center 636 Winchester Rd Libertyville, IL 60048 USA</p> <p>Salesperson: AMANDA SCHWARTZ Phone: (720) 326-1165 Email: amandas@xybix.com</p>
---------------------------------------------------------------------------------------------------------------------------------------------------------------------------------------------------------------------	----------------------------------------------------------------------------------------------------------------------------------------------------------------------------------------------------------------------------------------------------------------------

NASPO Contract # 00318
 Eagle Line w/axys
 Install Type: Standard
 Tax Exempt
 * NASPO Contract # 00318 pricing is conditional based on a complete order by December 31, 2023. KS

09.18.2023: R6 - All workstation items approved; Finishes selected; Cables determined. MND
 04.04.2023: Update Contract. MND
 02.28.2023 R4: Left side of room to have (3) horizontal zig zags of (4) - Straight station on left end; Right side of room to have (4) horizontal zig zags - top (3) with (4) - bottom of (6) curved; SUP 2nd opening ramp up in middle - move storage. MND
 01.20.2023: R3 - MND

Line	Part Num	Desc	Qty	U/M	List Ea.	Disc. %	Disc. Price	Net Price
1.00	12343.	Panel System Priced by the Linear Foot: Grade 3 Fabric 12343-1-DS - 29-48in - 365.5 LF @ \$380.00/LF Acrylic 16715 - Unlit & Blank - 321.0 LF @ 218.00/LF Upper Tiles Fabric Color: TBD Grade 3 G2 Lower Tiles Fabric Color: TBD Grade 3 G2 Panel Trim Color: Black	1	EA	\$208,868.00	51.00 %	\$102,345.32	\$102,345.32
1.01	13872-3D.	Panel Tile Panel Segment 3D Laminate 14h x 18w Upgrade	69	EA	\$19.00	51.00 %	\$9.31	\$9.31
1.02	13873-3D.	Panel Tile Panel Segment 3D Laminate 14h x 24w Upgrade	70	EA	\$19.00	51.00 %	\$9.31	\$9.31
1.03	13874-3D.	Panel Tile Panel Segment 3D Laminate 14h x 30w Upgrade	71	EA	\$23.00	51.00 %	\$11.27	\$45.08
1.04	13875-3D.	Panel Tile Panel Segment 3D Laminate 14h x 36w Upgrade	72	EA	\$23.00	51.00 %	\$11.27	\$67.62
1.05	13876-3D.	Panel Tile Panel Segment 3D Laminate 14h x 42w Upgrade	73	EA	\$23.00	51.00 %	\$11.27	\$67.62

Xybix Systems, Inc.
 8207 SouthPark Circle
 Littleton CO 80120
 Phone: 303-683-5656
 Fax: 303-683-5454
 meghand



Quote Number: 31923

Quote Date: 9/20/2023
 Revision: D
 Orig Create Date: 9/18/2023
 Expires: 12/17/2023
 Opp #: 0026249

Quote

Terms: NET 30

Page: 2 of 6

Line	Part Num	Desc	Qty	U/M	List Ea.	Disc. %	Disc. Price	Net Price
1.06	13877-3D.	Panel Tile Panel Segment 3D Laminate 14h x 48w Upgrade	⁷⁴	1.00 EA	\$23.00	51.00 %	\$11.27	\$11.27
1.07	13866-3D.	Panel Tile Panel Segment 3D Laminate 24h x 18w Upgrade	⁷⁵	1.00 EA	\$19.00	51.00 %	\$9.31	\$9.31
1.08	13867-3D.	Panel Tile Panel Segment 3D Laminate 24h x 24w Upgrade	⁷⁶	1.00 EA	\$19.00	51.00 %	\$9.31	\$9.31
1.09	13868-3D.	Panel Tile Panel Segment 3D Laminate 24h x 30w Upgrade	⁷⁷	4.00 EA	\$23.00	51.00 %	\$11.27	\$45.08
1.10	13869-3D.	Panel Tile Panel Segment 3D Laminate 24h x 36w Upgrade	⁷⁸	6.00 EA	\$23.00	51.00 %	\$11.27	\$67.62
1.11	13870-3D.	Panel Tile Panel Segment 3D Laminate 24h x 42w Upgrade	⁷⁹	6.00 EA	\$23.00	51.00 %	\$11.27	\$67.62
1.12	13871-3D.	Panel Tile Panel Segment 3D Laminate 24h x 48w Upgrade	⁸⁰	1.00 EA	\$23.00	51.00 %	\$11.27	\$11.27
2.00	14487-3D.	Adj. Table Worksurface - Corner Dual Surface - 84L x 84R - Cable Management Included	²	30.00 EA	\$2,780.00	51.00 %	\$1,362.20	\$40,866.00
2.01	14498-3D.	Adj. Table Worksurface - Straight Dual Surface - 90W x 44D - Cable Management Included	³	4.00 EA	\$1,847.00	51.00 %	\$905.03	\$3,620.12
3.00	15702	L5 Table Base	⁴	34.00 EA	\$8,471.00	51.00 %	\$4,150.79	\$141,126.86
4.00	15711	Monitor Arm Single - Adjustable - Silver - Kit	⁵	4.00 EA	\$237.00	51.00 %	\$116.13	\$464.52
4.01	16744.	Monitor Mount 3 - Rollervision - Corner Dual Surface - 84L x 84R 16676 - Std VESA Mount 2 HI 2 Knuckle Qty = 3 Total: \$2,580.00 16679 - Scissor Mount Qty = 2 Total: \$1,218.00	⁸	30.00 EA	\$6,161.00	51.00 %	\$3,018.89	\$90,566.70
4.02	16745.	Monitor Mount 3 - Rollervision - Straight Dual Surface - 90W x 44D 16676 - Std VESA Mount 2 HI 2 Knuckle Qty = 3 Total: \$2,580.00 16679 - Scissor Mount Qty = 1 Total: \$609.00	⁹	4.00 EA	\$5,552.00	51.00 %	\$2,720.48	\$10,881.92
5.00	16874	Display Port Cable 20 ft M/M	¹⁰	272.00 EA	\$124.00	51.00 %	\$60.76	\$16,526.72

OPEN MARKET

Xybix Systems, Inc.
 8207 SouthPark Circle
 Littleton CO 80120
 Phone: 303-683-5656
 Fax: 303-683-5454
 meghand



Quote Number: 31923

Quote Date: 9/20/2023
 Revision: D
 Orig Create Date: 9/18/2023
 Expires: 12/17/2023
 Opp #: 0026249

Quote

Terms: NET 30

Page: 3 of 6

Line	Part Num	Desc	Qty	U/M	List Ea.	Disc. %	Disc. Price	Net Price
5.01	16873	HDMI Cable 20 ft M/M	11	68.00 EA	\$124.00	51.00 %	\$60.76	\$4,131.68
		OPEN MARKET						
5.02	12787	USB Type A to Type A Keyboard/Mouse Extension 5M (16' 4") - Color: BLACK	81	68.00 EA	\$49.00	51.00 %	\$24.01	\$1,632.68
5.03	16130-8	Datadock2 - Keyboard Snap-In Cable Organizer Includes: 8 - USB Ports 1 - RJ45 Port	12	34.00 EA	\$709.00	51.00 %	\$347.41	\$11,811.94
5.04	15822	Lift Case additional Energy Chains NO PULL	56	4.00 EA	\$258.00	51.00 %	\$126.42	\$505.68
5.05	11683	Energy Chain 22-48 Monitor Surface	57	4.00 EA	\$275.00	51.00 %	\$134.75	\$539.00
6.00	15848	Grounding Kit Full Station R56 Compliant	13	34.00 EA	\$1,539.00	51.00 %	\$754.11	\$25,639.74
6.01	11792-BLK	Power Bar - 10 Outlet With Black Sticker	14	34.00 EA	\$170.00	51.00 %	\$83.30	\$2,832.20
6.02	11792-OR	Power Bar - 10 Outlet With Orange Sticker	15	34.00 EA	\$170.00	51.00 %	\$83.30	\$2,832.20
6.03	14976	6 Outlet Power Strip 25'	16	28.00 EA	\$180.00	51.00 %	\$88.20	\$2,469.60
6.04	16891	Grommet, Round, 80 mm, Power Data, 2 AC Outlet, 1 USB Charge, 1 USB-C Charge, 1 CAT6, 1 HDMI, Black, 6 ft	17	42.00 EA	\$150.00	51.00 %	\$73.50	\$3,087.00
		OPEN MARKET						
7.00	16708.	Axys Control System with Fan Base Price: \$2,121.00 16707AXS - Heat - \$675.00 - OPEN MARKET 16709AXS - Task Lights - \$270.00 - OPEN MARKET 16711AXS - Footwell Lighting - \$259.00 - OPEN MARKET 16712AXS - Down Bias Lighting - \$159.00 - OPEN MARKET 16713AXS - Arc Lighting - \$530.00 - OPEN MARKET 16771AXS - Axys Status Light 3 HI - \$1,754.00 - OPEN MARKET	20	34.00 EA	\$5,768.00	51.00 %	\$2,826.32	\$96,094.88
7.01	15560	Acrylic Cleaning Kit	21	4.00 EA	\$134.00	51.00 %	\$65.66	\$262.64
8.00	16909	Shelf, Under Surface, With Power, 1 AC Outlet, 1 USB Charge, 1 USB-C Charge, Metal, Black	26	34.00 EA	\$364.00	51.00 %	\$178.36	\$6,064.24

Xybix Systems, Inc.
 8207 SouthPark Circle
 Littleton CO 80120
 Phone: 303-683-5656
 Fax: 303-683-5454
 meghand



Quote Number: 31923

Quote Date: 9/20/2023
 Revision: D
 Orig Create Date: 9/18/2023
 Expires: 12/17/2023
 Opp #: 0026249

Quote

Terms: NET 30

Page: 4 of 6

Line	Part Num	Desc	Qty	U/M	List Ea.	Disc. %	Disc. Price	Net Price
10.00	12030-3D.	Return Worksurface - 36Wx23.5D	28	1.00 EA	\$491.00	51.00 %	\$240.59	\$240.59
10.01	12030-3D.	Return Worksurface - 42Wx23.5D	29	1.00 EA	\$491.00	51.00 %	\$240.59	\$240.59
10.02	12031-3D.	Return Worksurface - 66Wx23.5D	58	5.00 EA	\$822.00	51.00 %	\$402.78	\$2,013.90
10.03	12031-3D.	Return Worksurface - 78Wx23.5D	59	1.00 EA	\$822.00	51.00 %	\$402.78	\$402.78
10.04	12033-3D.	Return Worksurface - 18Wx36D	31	4.00 EA	\$656.00	51.00 %	\$321.44	\$1,285.76
10.05	12033-3D-FT.	Flip Top Return Worksurface - 18Wx36D	30	28.00 EA	\$656.00	51.00 %	\$321.44	\$9,000.32
10.06	12033-3D-FT.	Flip Top Return Worksurface - 36Wx36D	32	2.00 EA	\$656.00	51.00 %	\$321.44	\$642.88
10.07	12034-3D.	Return Worksurface - 60Wx36D	33	1.00 EA	\$822.00	51.00 %	\$402.78	\$402.78
10.08	12035-3D.	Return Worksurface - 84Wx36D	35	11.00 EA	\$1,183.00	51.00 %	\$579.67	\$6,376.37
10.09	12034-3D.	Triangle Return Worksurface - 54Wx36D	60	14.00 EA	\$822.00	51.00 %	\$402.78	\$5,638.92
10.10	12035-3D.	Triangle/Ped Return Worksurface - 80.5Wx38D	36	11.00 EA	\$1,183.00	51.00 %	\$579.67	\$6,376.37
10.11	12033-3D.	Return Worksurface - 33.25Wx44D	61	3.00 EA	\$656.00	51.00 %	\$321.44	\$964.32
10.12	12033-3D.	Return Worksurface - 42Wx44D	62	1.00 EA	\$656.00	51.00 %	\$321.44	\$321.44
11.00	16209	Cable Bridge Corner Angled Left Side	37	16.00 EA	\$261.00	51.00 %	\$127.89	\$2,046.24
11.01	16210	Cable Bridge Corner Angled Right Side	38	17.00 EA	\$261.00	51.00 %	\$127.89	\$2,174.13
11.02	15709	Cable Bridge Straight Left Side	39	4.00 EA	\$261.00	51.00 %	\$127.89	\$511.56
11.03	15447-3D.	CPU Cabinet - ERGO ACCESS Tech Tower 18Wx42H Left Access	40	1.00 EA	\$2,088.00	51.00 %	\$1,023.12	\$1,023.12
11.04	15220-3D.	CPU Cabinet - ERGO ACCESS Tech Tower 18Wx48H Left Access	41	6.00 EA	\$2,115.00	51.00 %	\$1,036.35	\$6,218.10
11.05	15220-3D.	CPU Cabinet - ERGO ACCESS Tech Tower 18Wx48H Right Access	82	5.00 EA	\$2,115.00	51.00 %	\$1,036.35	\$5,181.75
11.06	15223-3D.	CPU Cabinet - ERGO ACCESS Back To Back 18Wx48H	63	3.00 EA	\$3,716.00	51.00 %	\$1,820.84	\$5,462.52

Xybix Systems, Inc.
 8207 SouthPark Circle
 Littleton CO 80120
 Phone: 303-683-5656
 Fax: 303-683-5454
 meghand



Quote Number: 31923

Quote Date: 9/20/2023
 Revision: D
 Orig Create Date: 9/18/2023
 Expires: 12/17/2023
 Opp #: 0026249

Quote

Terms: NET 30

Page: 5 of 6

Line	Part Num	Desc	Qty	U/M	List Ea.	Disc. %	Disc. Price	Net Price
11.07	15482-3D-FT.	CPU Cabinet - ERGO ACCESS Under Work Surface 18Wx34.5D With Flip Top Hinge	42	28.00 EA	\$1,469.00	51.00 %	\$719.81	\$20,154.68
11.08	15488-3D-FT.	CPU Cabinet - ERGO ACCESS Under Work Surface 36Wx34.5D With Flip Top Hinge	43	2.00 EA	\$1,807.00	51.00 %	\$885.43	\$1,770.86
12.00	11352-3D.	Drawer Pedestal - Fixed - Single - 18W - 6-6-12 Drawers 18W 22D	44	23.00 EA	\$1,404.00	51.00 %	\$687.96	\$15,823.08
12.01	13642-3D.	Drawer Pedestal - Fixed - Bookcase Right - 33.25W - 6-6-12 Drawers 18W 22D	64	3.00 EA	\$1,626.00	51.00 %	\$796.74	\$2,390.22
14.00	10703-3D.	Lateral File - 30W2 Drawer 30H	45	11.00 EA	\$1,894.00	51.00 %	\$928.06	\$10,208.66
14.01	11668-3D.	Lateral File - 36W2 Drawer 30H	46	11.00 EA	\$1,971.00	51.00 %	\$965.79	\$10,623.69
14.02	10704-3D.	Lateral File - 30W3 Drawer 42H	47	5.00 EA	\$2,504.00	51.00 %	\$1,226.96	\$6,134.80
14.03	12026-3D.	Lateral File - 36W3 Drawer 42H	48	7.00 EA	\$2,655.00	51.00 %	\$1,300.95	\$9,106.65
14.04	12920-3D.	Lateral File - 42W3 Drawer 42H	49	2.00 EA	\$2,759.00	51.00 %	\$1,351.91	\$2,703.82
15.00	13615-3D.	Triangle Bookcase - UnderWS W/Toekick - 42W, 28H, 13D	50	25.00 EA	\$929.00	51.00 %	\$455.21	\$11,380.25
15.01	13615-3D.	Bookcase - UnderWS W/Toekick - 42W, 28H, 22D, Curved Left	65	1.00 EA	\$929.00	51.00 %	\$455.21	\$455.21
15.02	13615-3D.	Bookcase - UnderWS W/Toekick - 42W, 28H, 22D	66	1.00 EA	\$929.00	51.00 %	\$455.21	\$455.21
15.03	13616-3D-MS20.	Above WorkSurface - 42W, 19.5H, 13D with 20 Mailslots.	51	2.00 EA	\$1,547.00	51.00 %	\$758.03	\$1,516.06
16.00	13672-3D.	Storage Cabinet - UnderWS W/Toekick - 18W, 28H, 22D	52	15.00 EA	\$1,014.00	51.00 %	\$496.86	\$7,452.90
18.00	14655	Wall Screw Anchor Kit	83	1.00 EA	\$15.00	51.00 %	\$7.35	\$7.35
90.00	16139	Installers Kit Eagle Line	54	34.00 EA	\$0.00	0.00 %	\$0.00	\$0.00
99.00	Other	Other Charges & Services	55	1.00 EA	\$0.00	0.00 %	\$0.00	\$0.00
Line (55) - Miscellaneous Charge -								
Description							Ext. Price	
1.) Freight - Full Truck (x3)							9,621.00	
2.) Installation							92,152.50	

Xybix Systems, Inc.
 8207 SouthPark Circle
 Littleton CO 80120
 Phone: 303-683-5656
 Fax: 303-683-5454
 meghand



Quote Number: 31923

Quote Date: 9/20/2023
Revision: D
Orig Create Date: 9/18/2023
Expires: 12/17/2023
Opp #: 0026249

Quote

Terms: NET 30

Page: 6 of 6

Line	Part Num	Desc	Qty	U/M	List Ea.	Disc. %	Disc. Price	Net Price
List Price Total:					\$1,472,306.00			Lines Total: \$721,429.94
								Line Miscellaneous Charges Total: \$101,773.50
								Taxes Total: \$0.00
								Quote Total: \$823,203.44

Note 1:
 All quoted taxes are estimated. Any applicable taxes, fees, permits, etc. must be added to this quote.

Note 2:
 Where installation is listed on quote it is based in non-union labor and on one trip for installation only. Client is responsible for coordination of Technicians and other Vendors/Contractors. Waiting time will be charged at the rate of \$75 per man hour straight time and \$115 per man hour for OT plus subsistence expenses.
 Additionally, this quote is based upon a remodel in an existing space and/or new building - completely finished with a Certificate of Occupancy. Any project where the General Contractor is still on the job is subject to additional charges.

We appreciate this opportunity to provide this quote. Our goal is to substantially improve working conditions for your valuable staff. We look forward to meeting with you to review this proposal in detail. In the meantime please don't hesitate to call us with any questions.

Xybix Systems, Inc.
 8207 SouthPark Circle
 Littleton CO 80120
 Phone: 303-683-5656
 Fax: 303-683-5454
 megchand



Quote Number: 32291

Quote Date: 9/20/2023
 Revision: C
 Orig Create Date: 9/19/2023
 Expires: 12/18/2023
 Opp #: 0027369

Quote

Terms: NET 30

Page: 1 of 2

<p>QUOTE TO: Acct: LAKCOULIL</p> <p>Lake County 911 Dispatch Center 18 N County Street 8th Floor Waukegan IL 60048</p> <p>Phone: Email:</p>	<p>SHIP TO: Lake County 911 Dispatch Center - Backup 636 Winchester Rd Libertyville, IL 60048 USA</p> <p>Salesperson: AMANDA SCHWARTZ Phone: (720) 326-1165 Email: amandas@xybix.com</p>
---------------------------------------------------------------------------------------------------------------------------------------------------------------------------------------------------------------------	-------------------------------------------------------------------------------------------------------------------------------------------------------------------------------------------------------------------------------------------------------------------------------

NASPO Contract # 00318
 Product Line: Eagle Line
 Install Type: Standard
 Tax Exempt

- * To ship & install with OPP 0026249. If items do not ship & install together, additional fees will apply.
- * Freight is listed on QUOTE 31923
- * 51% Discount honored only if items ship and install together
- * NASPO Contract # 00318 pricing is conditional based on a complete order by December 31, 2023. KS

09.19.2023: R3 - Remove retractable/folding doors; Original Finish selection chosen; Cables determined. Remove soffit. MND
 04.10.2023: R1 - Remove: Nesting Tables & Podium. MND
 03.31.2023: R0 - Drawing Creation - MND

Line	Part Num	Desc	Qty	U/M	List Ea.	Disc. %	Disc. Price	Net Price
1.00	12344.	Panel System Priced by the Linear Foot: Grade 3 Fabric 12344-1-SS - 65in - 34.0 LF @ \$376.00/LF 12344-1-DS - 65in - 5.0 LF @ \$522.00/LF Upper Tiles Fabric Color: TBD Grade 3 G2 Lower Tiles Fabric Color: TBD Grade 3 G2 Panel Trim Color: Black	1	EA	\$15,394.00	51.00 %	\$7,543.06	\$7,543.06
4.00	16747.	Monitor Mount 3 - Fixed on WS - Straight - 48W x 30D 16676 - Std VESA Mount 2 HI 2 Knuckle Qty = 2 Total: \$1,720.00	25	EA	\$3,307.00	51.00 %	\$1,620.43	\$9,722.58
5.00	14342	Display Port Cable 15 ft Male/Male	23	EA	\$104.00	51.00 %	\$50.96	\$1,223.04
5.01	15561	Cable Management J Channel 3.5"Top x 2.5" Height- 5.45"Bottom	8	FT	\$23.00	51.00 %	\$11.27	\$270.48
6.00	11792-OR	Power Bar - 10 Outlet With Orange Sticker	9	EA	\$170.00	51.00 %	\$83.30	\$499.80
6.01	16891	Grommet, Round, 80 mm, Power Data, 2 AC Outlet, 1 USB Charge, 1 USB-C Charge, 1 CAT6, 1 HDMI, Black, 6 ft	10	EA	\$150.00	51.00 %	\$73.50	\$441.00

Xybix Systems, Inc.
 8207 SouthPark Circle
 Littleton CO 80120
 Phone: 303-683-5656
 Fax: 303-683-5454
 meghand



Quote Number: 32291

Quote Date: 9/20/2023
 Revision: C
 Orig Create Date: 9/19/2023
 Expires: 12/18/2023
 Opp #: 0027369

Quote

Terms: NET 30


Page: 2 of 2

Line	Part Num	Desc	Qty	U/M	List Ea.	Disc. %	Disc. Price	Net Price
OPEN MARKET								
6.02	14976	6 Outlet Power Strip 25'	13	6.00 EA	\$180.00	51.00 %	\$88.20	\$529.20
10.00	12031-3D.	Return Worksurface - 60.87Wx24D	14	6.00 EA	\$822.00	51.00 %	\$402.78	\$2,416.68
11.00	15894-HP	CPU Hanger, High Profile	15	12.00 EA	\$121.00	51.00 %	\$59.29	\$711.48
16.00	C-13675-3D.	Storage Cabinet - Above WorkSurface - 30W, 18H, 22D Wall Mounted, with lighting	24	4.00 EA	\$1,766.00	51.00 %	\$865.34	\$3,461.36
16.01	C-13675-3D.	Storage Cabinet - Above WorkSurface - 33.25W, 18H, 22D Wall Mounted	22	8.00 EA	\$1,766.00	51.00 %	\$865.34	\$6,922.72
18.00	16877.	Under Surface Support Bars Priced by Linear Foot: 5.0ft	16	6.00 EA	\$250.00	51.00 %	\$122.50	\$735.00
OPEN MARKET								
18.02	12235	Support - "L" Bracket 18"	18	12.00 EA	\$55.00	51.00 %	\$26.95	\$323.40
90.00	16139	Installers Kit Eagle Line	20	6.00 EA	\$0.00	0.00 %	\$0.00	\$0.00
99.00	Other	Other Charges & Services	21	1.00 EA	\$0.00	0.00 %	\$0.00	\$0.00
Line (21) - Miscellaneous Charge -								
							Description	Ext. Price
							2.) Installation	10,267.50
List Price Total:			\$71,020.00	Lines Total:		\$34,799.80		
				Line Miscellaneous Charges Total:		\$10,267.50		
				Taxes Total:		\$0.00		
				Quote Total:		\$45,067.30		

Note 1:
 All quoted taxes are estimated. Any applicable taxes, fees, permits, etc. must be added to this quote.

Note 2:
 Where installation is listed on quote it is based in non-union labor and on one trip for installation only. Client is responsible for coordination of Technicians and other Vendors/Contractors. Waiting time will be charged at the rate of \$75 per man hour straight time and \$115 per man hour for OT plus subsistence expenses.
 Additionally, this quote is based upon a remodel in an existing space and/or new building - completely finished with a Certificate of Occupancy. Any project where the General Contractor is still on the job is subject to additional charges.


We appreciate this opportunity to provide this quote. Our goal is to substantially improve working conditions for your valuable staff. We look forward to meeting with you to review this proposal in detail. In the meantime please don't hesitate to call us with any questions.

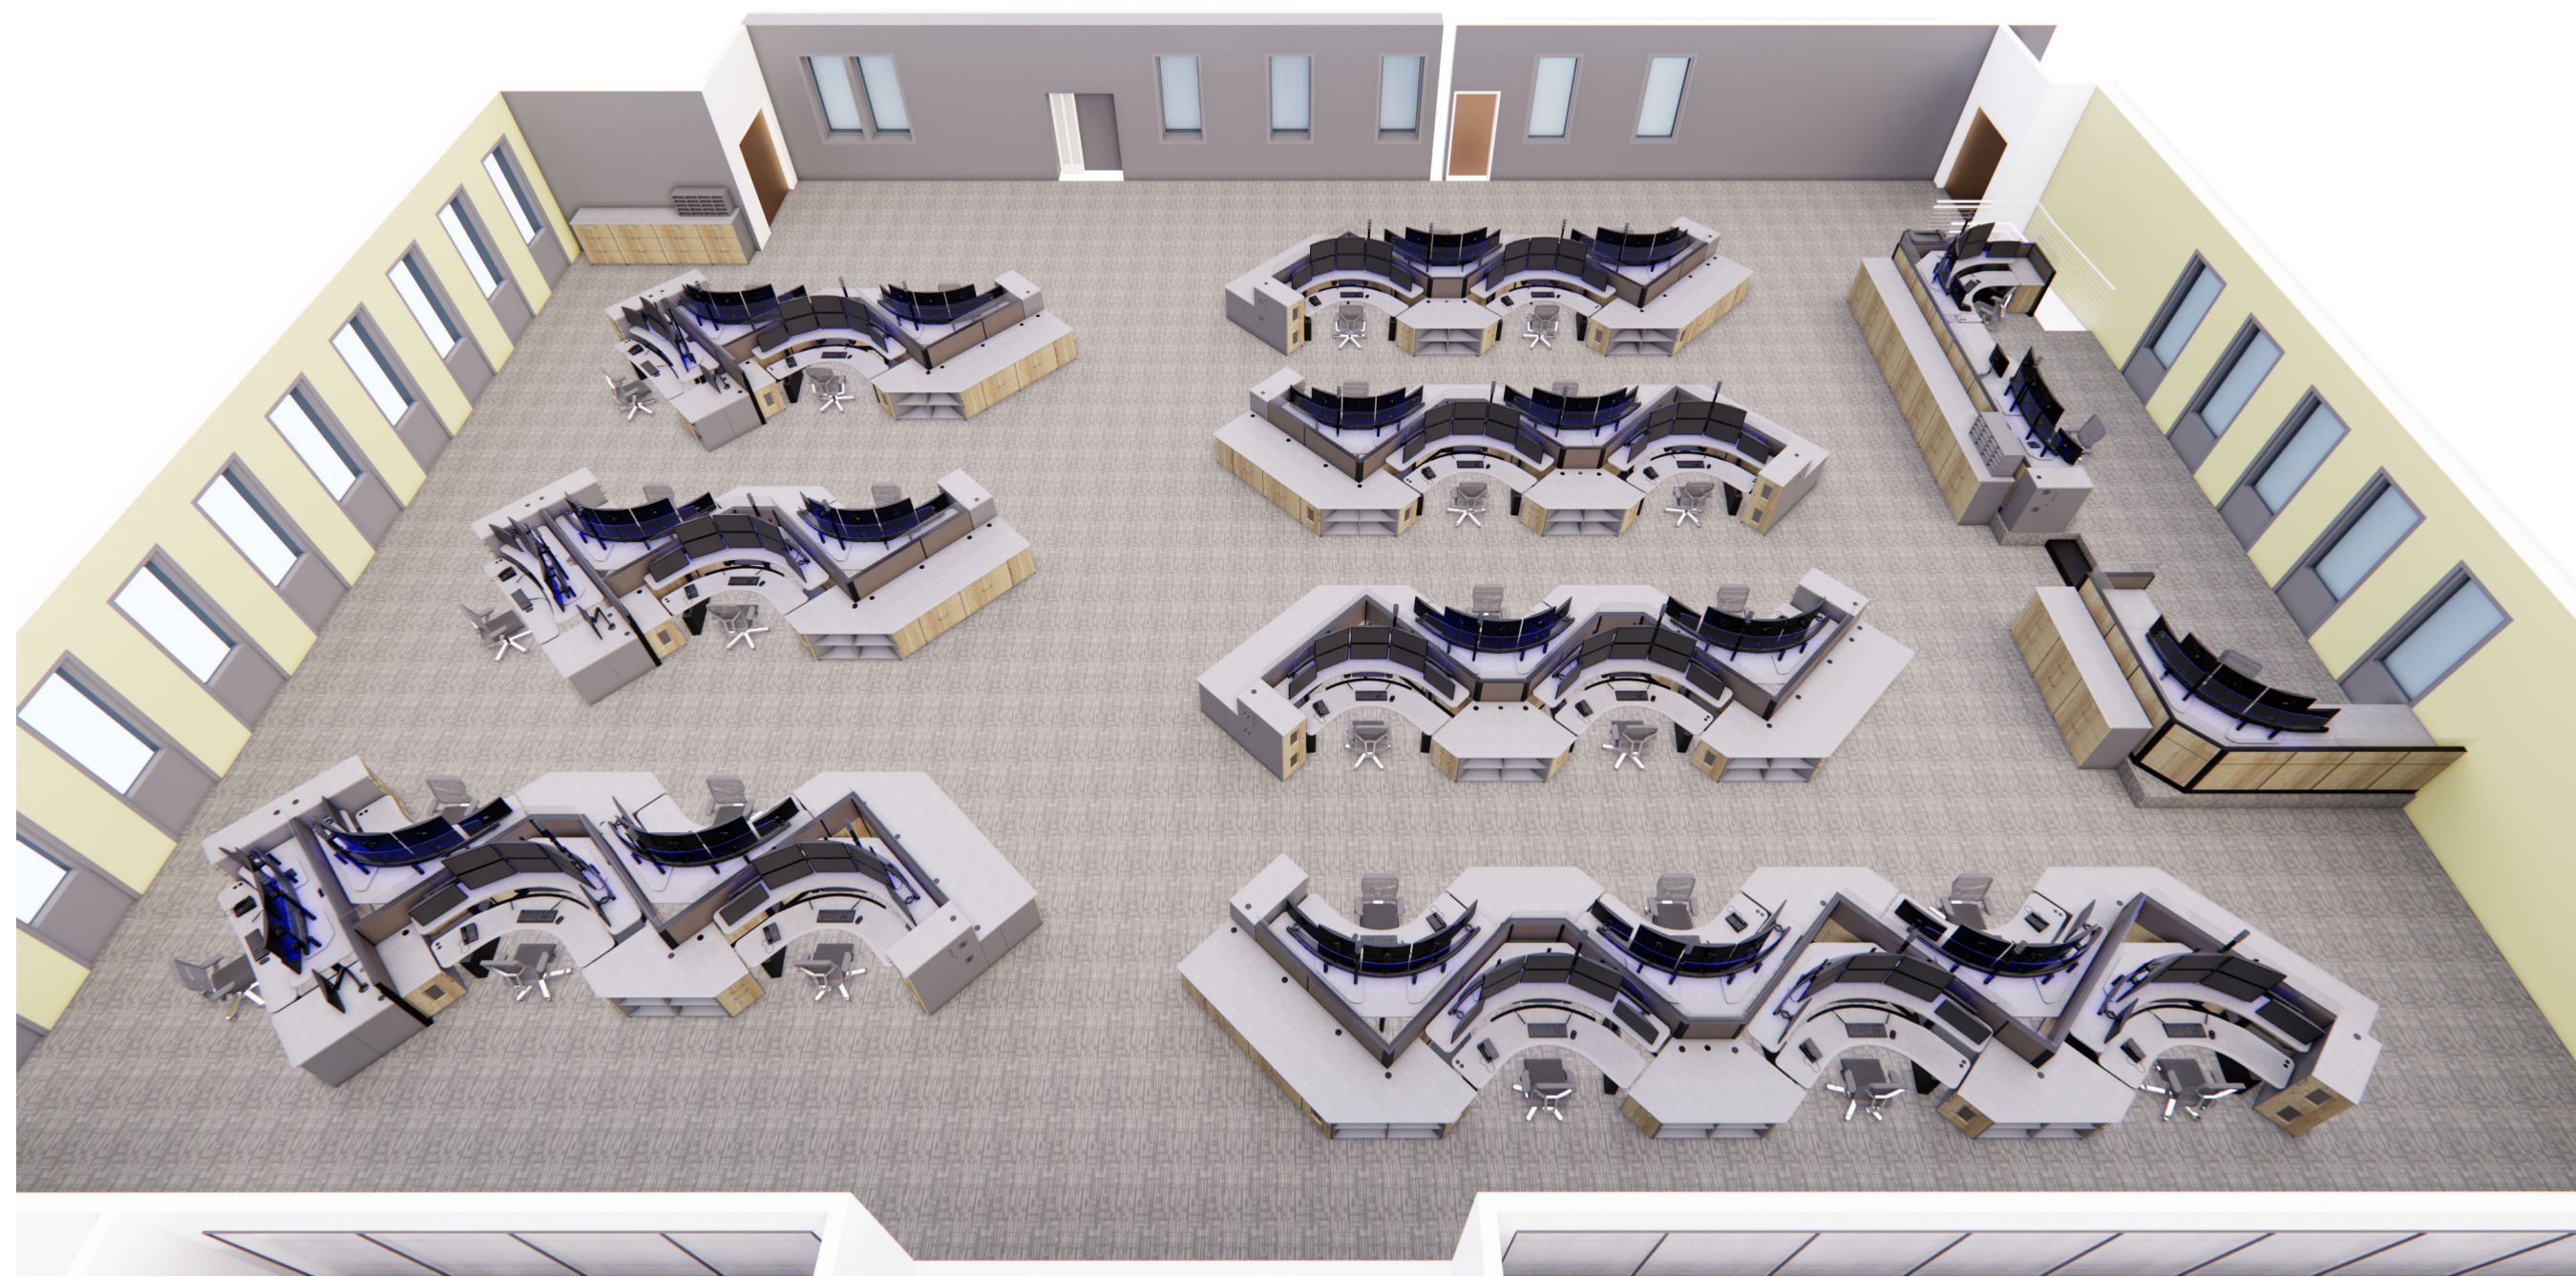

① 3D
12" = 1'-0"



② ZIGZAG
12" = 1'-0"

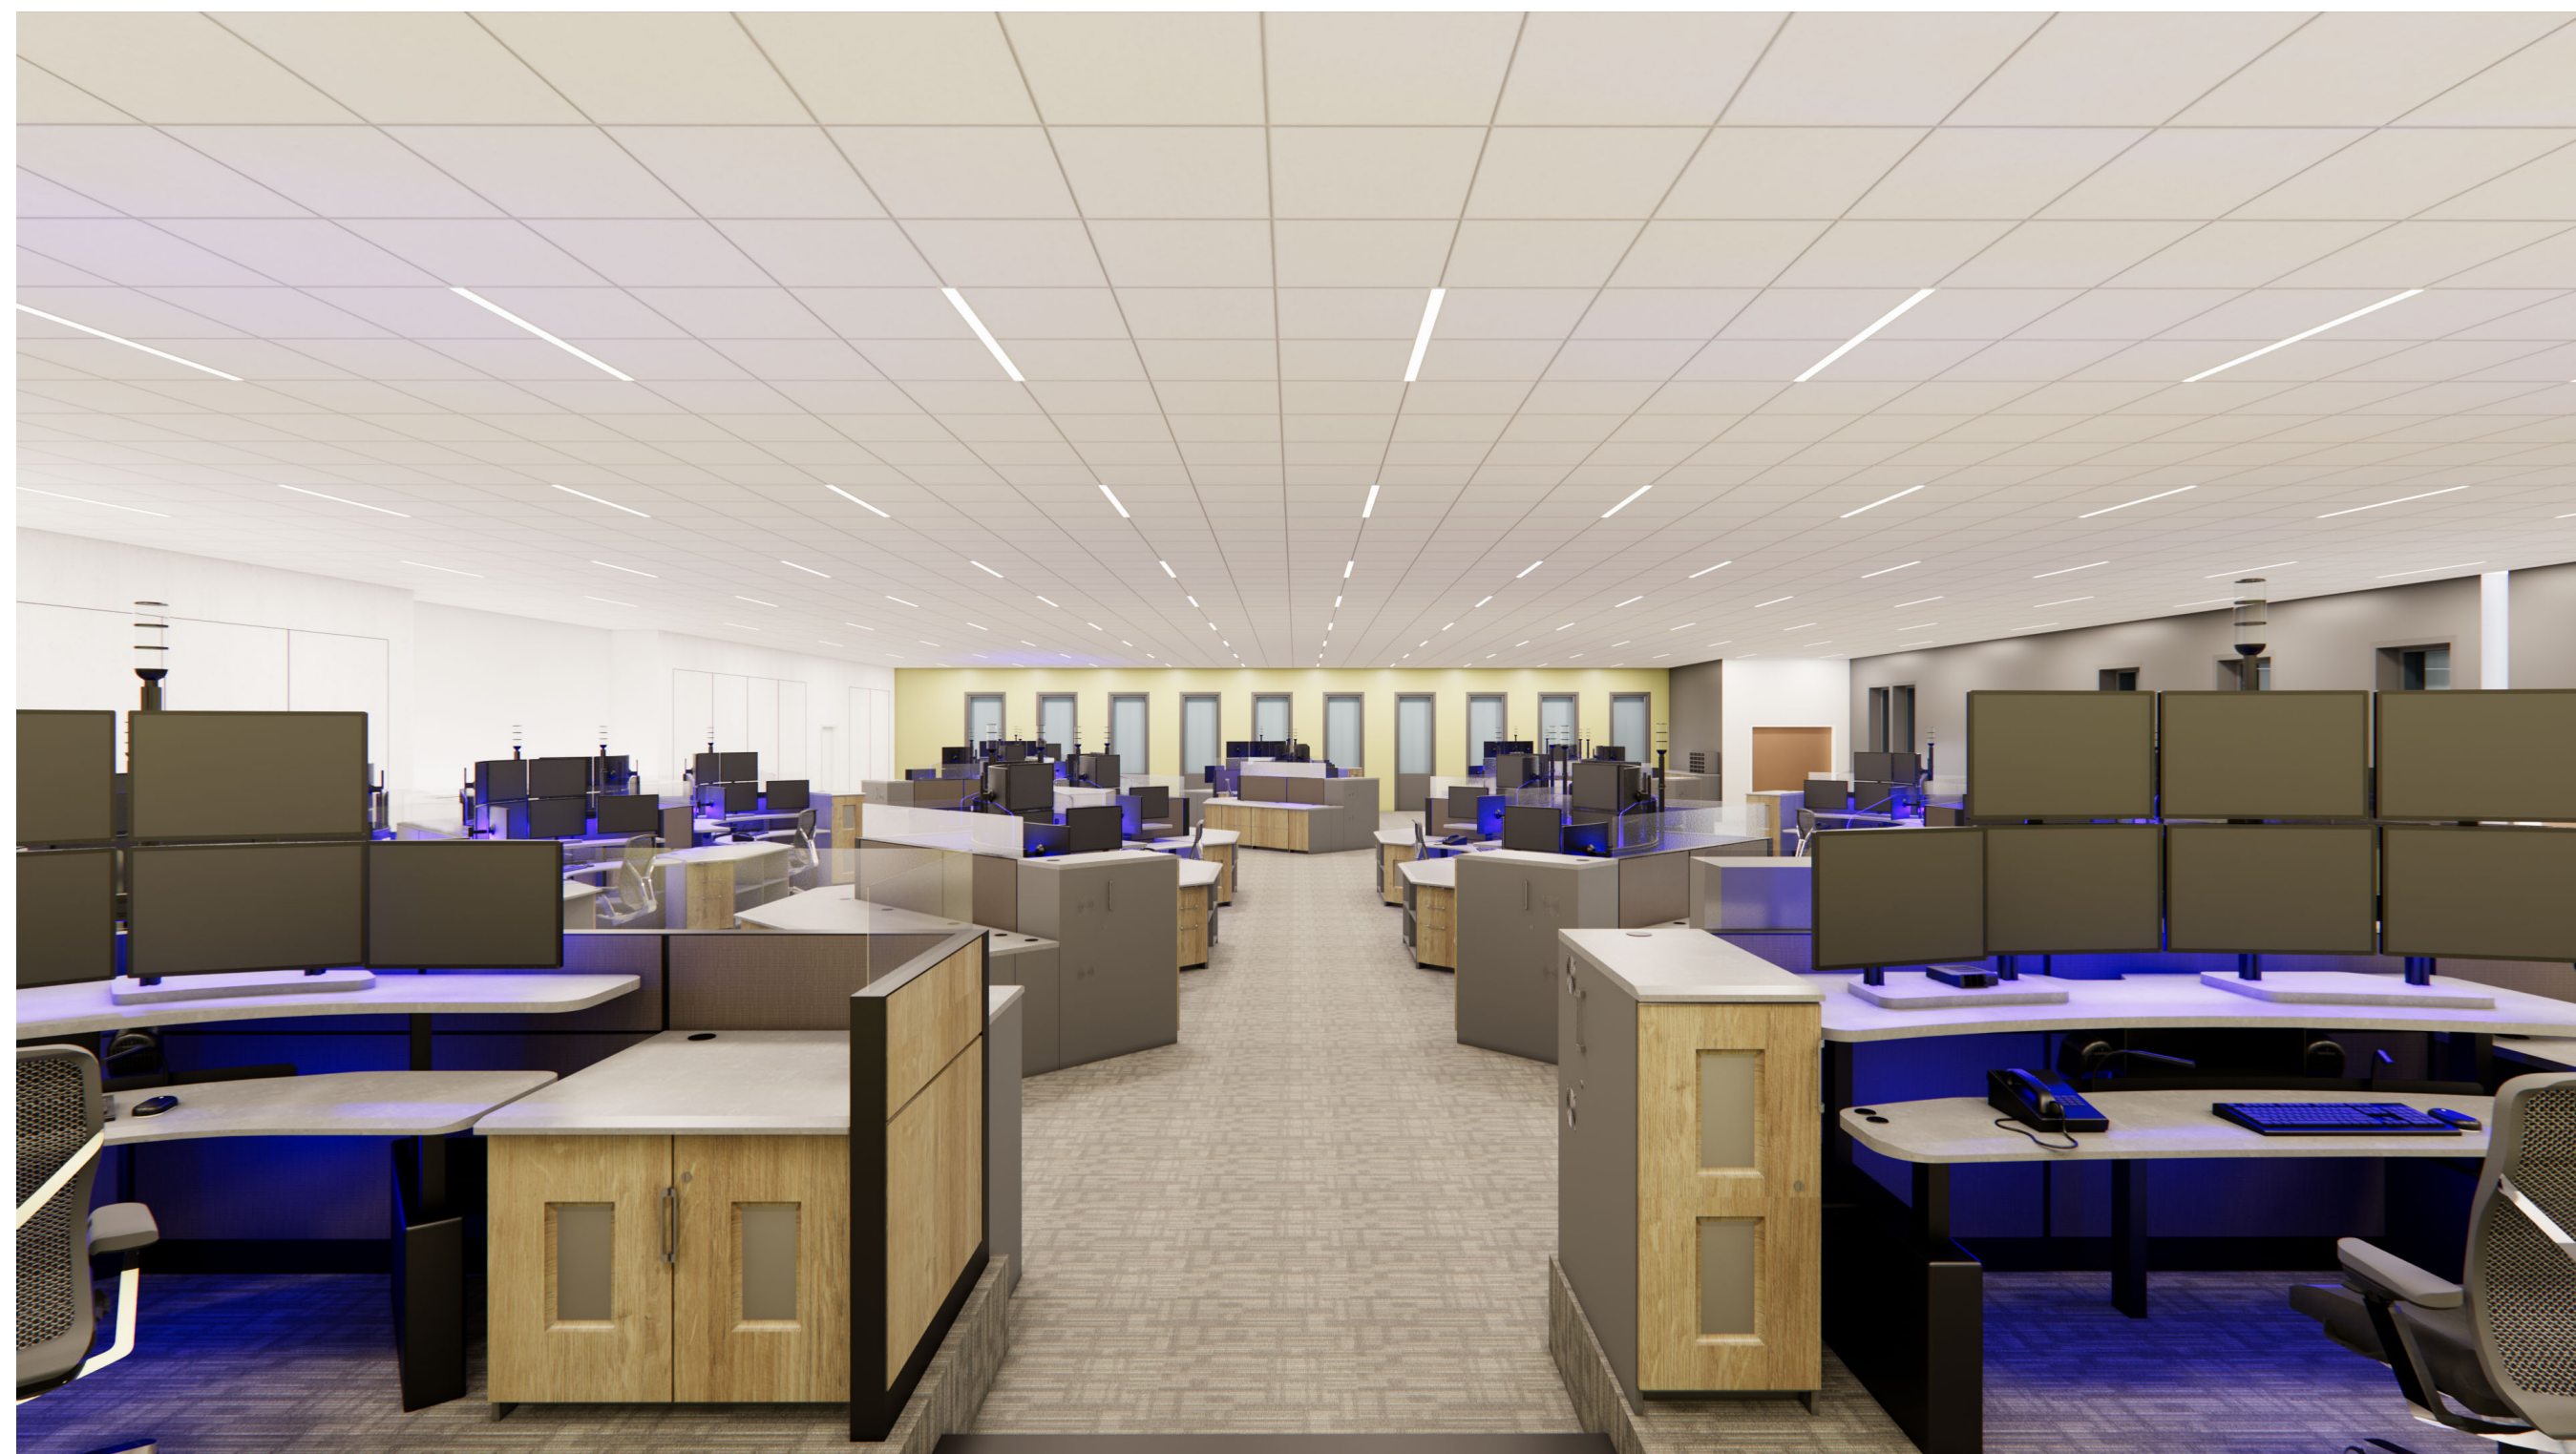

③ FROM SUP
12" = 1'-0"



④ PLATFORM
12" = 1'-0"

REV	DESIGNER	DATE	DESCRIPTION
3	MND	12.21.22	Updated Zigzag (4) rows of (2) and SUP Platform. Left side of room to have (3) horizontal zig zags of (4) - Straight station on left end; Right side of room to have (4) horizontal zig zags - top (3) with (4) - bottom of (6) curved; SUP 2nd opening ramp up in middle - move storage
4	MND	2.28.23	48H Panels. Azyllic to be frosted. Remove Cup Holders. Cables determined
5	MND	08.31.23	All workstation items approved. Finishes selected. Cables determined
6	MND	09.18.23	

PAGE #	PAGE NAME
6.0	FINISH SELECTION
7.0	CABLE SHEET
D1.0	ADDITIONAL RENDERINGS
D2.00	FLOOR PLAN - ZIGZAG
D3.0	TYPICALS
D4.0	ELEVATIONS
D8.0	HOLE LOCATION PLAN- WS
1-4	



8207 SouthPark Circle
Littleton, CO, 80120
1.800.788.2810 F. 303.683.5454
www.xybix.com


Sales : Amanda Schwartz
Email : AmandaS@xybix.com
Designer : Meghan Dinardi
Email : MeghanD@xybix.com

Lake County Regional 911 PSAP Consolidation
636 Winchester Rd
Libertyville, IL 60048

Opportunity: 0026249
Carpet Opp: N/A
Drawing Name:
FLOOR PLAN - ZIGZAG
SHEET: D2.00 SCALE: 1/4" = 1'-0"
NOTE: This design & layout is the property of XYBIX Systems, Inc. & is not to be used in any written manner without express written permission by XYBIX Systems, Inc.
Sign-Off Initials: REV 6

DESIGNER	DATE
MND	12.21.22
MND	2.28.23
MND	08.31.23
MND	09.18.23

REV	DESCRIPTION
3	Updated Zigzag (4) rows of (2) and SUP Platform.
4	Left side of room to have (3) horizontal zig zags of (4) - Straight station on left end; Right side of room to have (4) horizontal zig zags - top (3) with (4) - bottom of (6) curved; SUP 2nd opening ramp up in middle - move storage
5	48H Panels. Asrylic to be frosted. Remove Cup Holders. Cables determined
6	All workstation items approved. Finishes selected. Cables determined

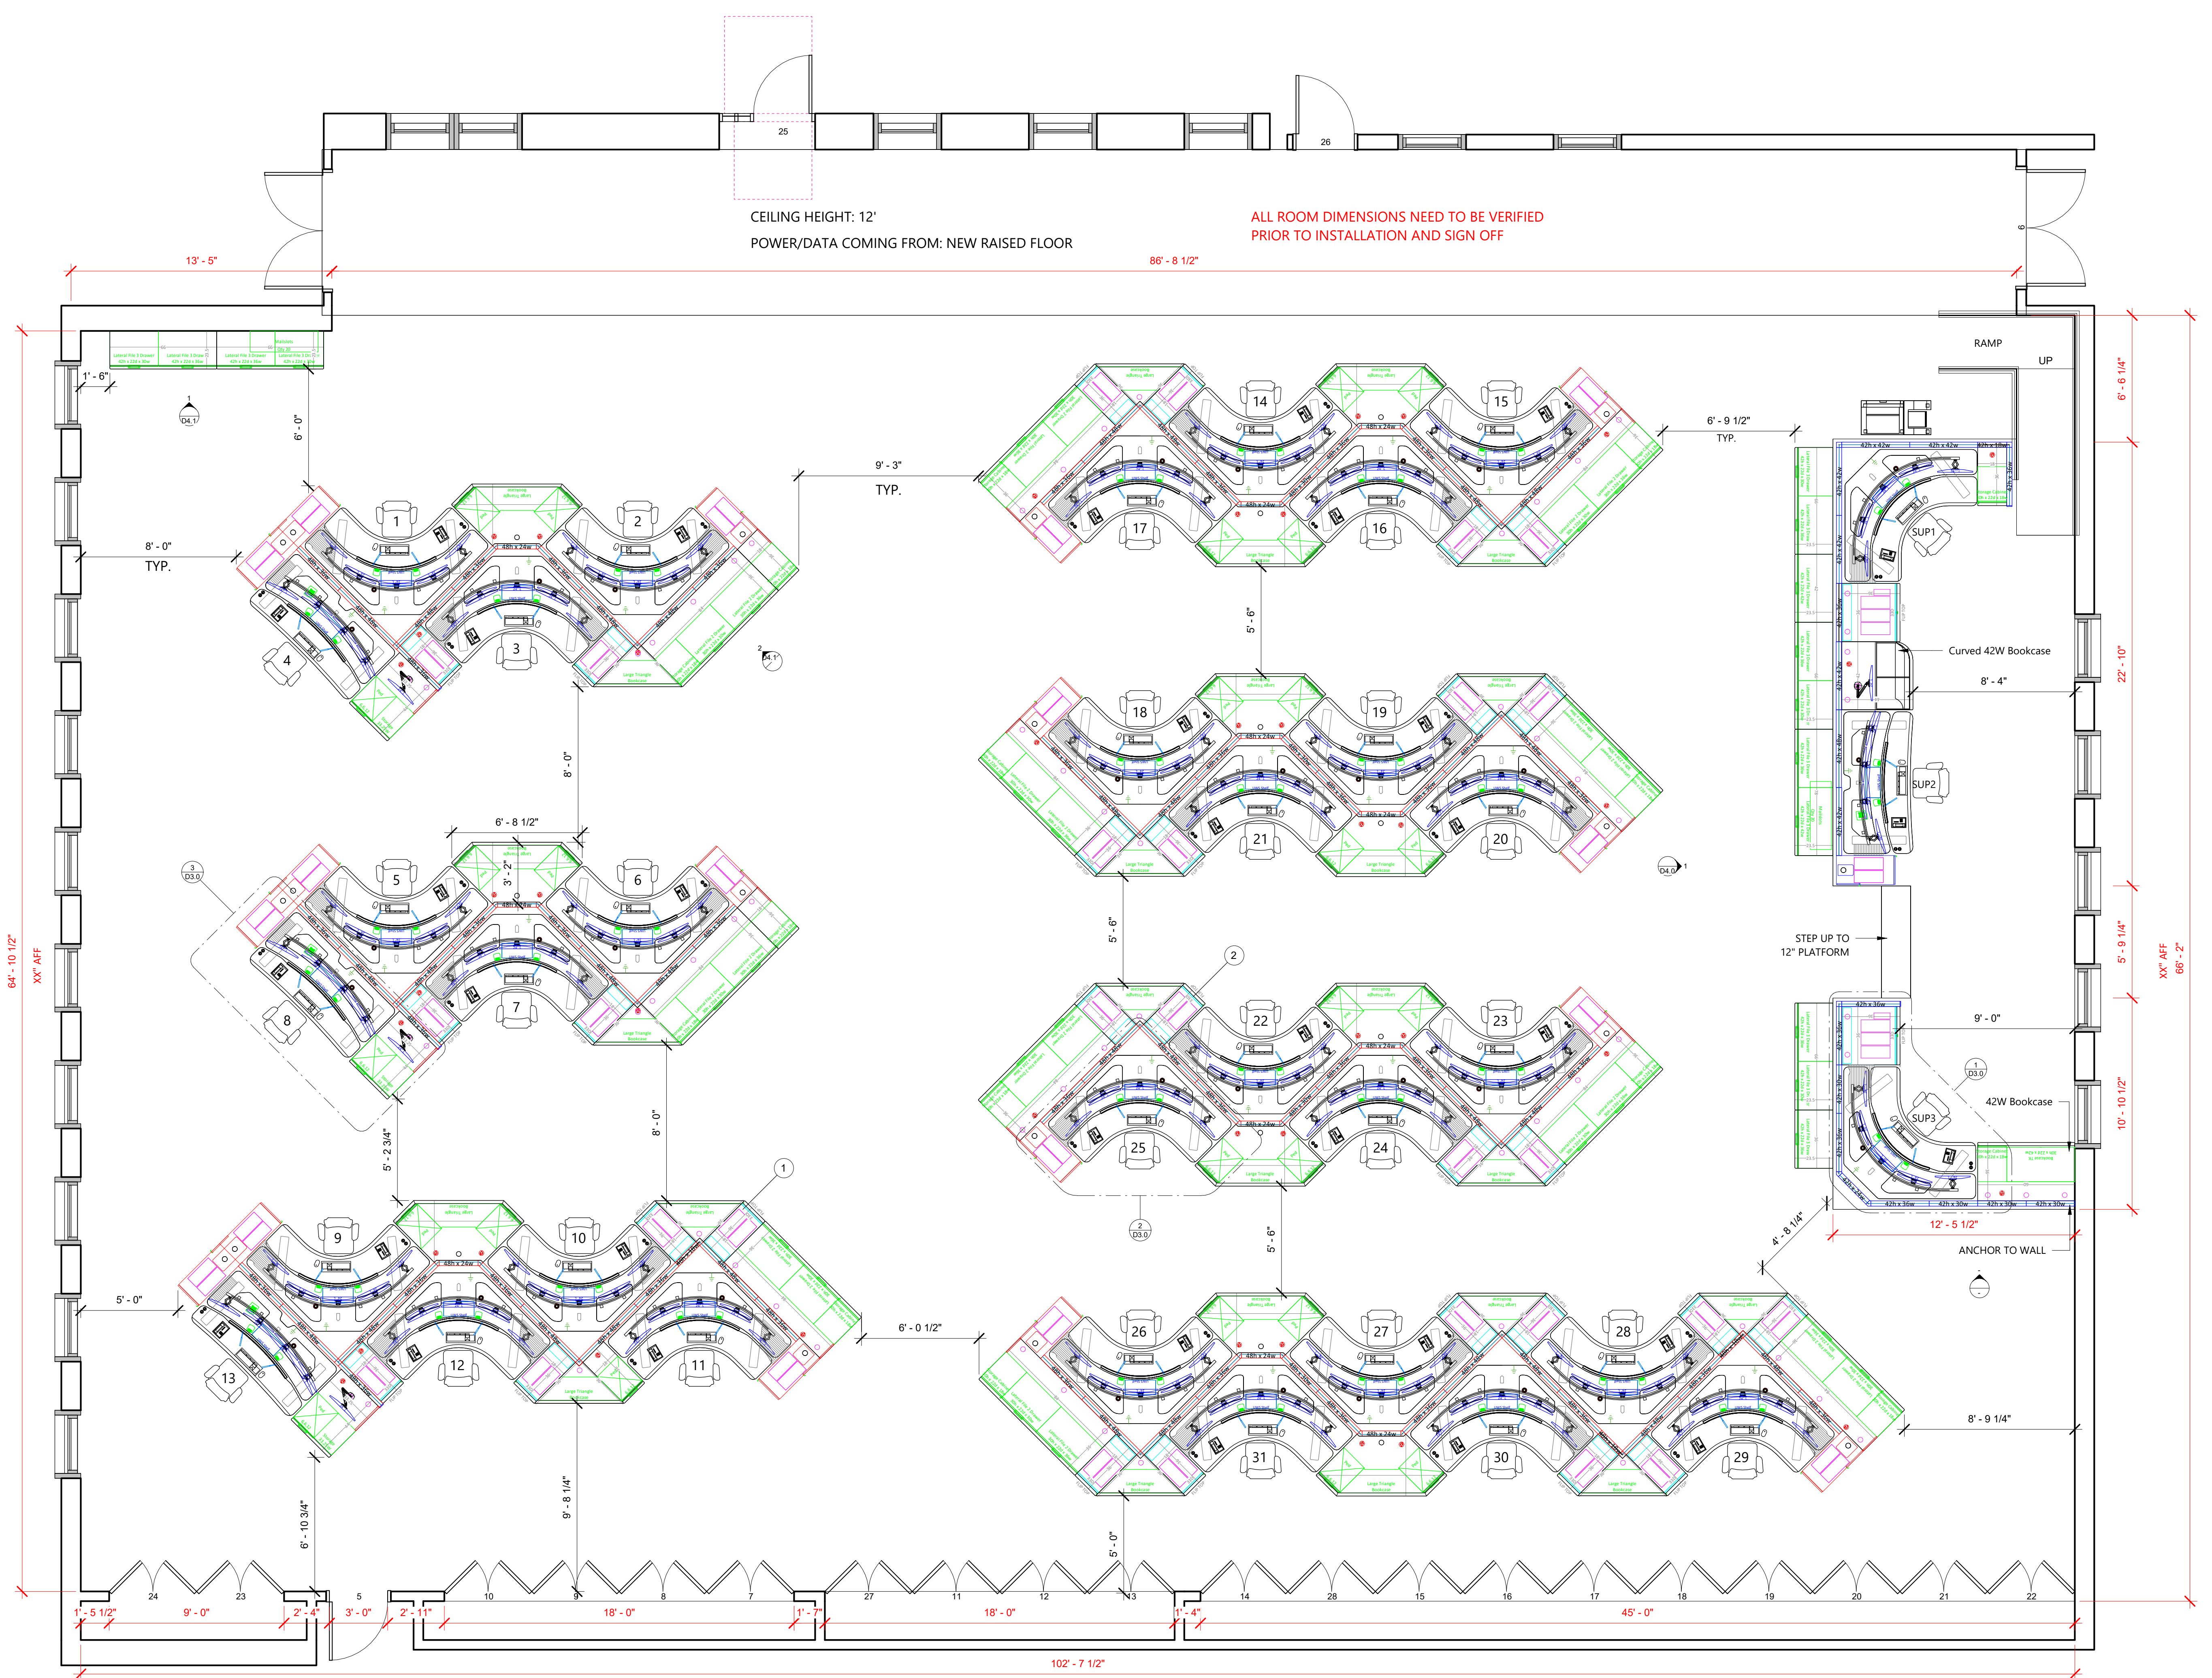

1 FLOOR PLAN - ZIGZAG
1/4" = 1'-0"

SIGN OFF APPROVAL: Furniture orders and product installation shall not proceed until the Client has given approval to these documents. Approval of the Client shall constitute approval of the drawings for contents, scope of work and all dimensions regarded by the Client as being necessary to the use of space, furnishings and equipment. Furniture orders, or product installation authorized by the Client from these documents, shall be interpreted by XYBIX as approval in full to these documents by the Client. Revisions after approval of these documents shall result in additional costs.

Signature: _____ Title: _____ Date: _____

Xybix 84"x84" Dual Surface Console:
Sit to stand adjustment range of 22"-48" AFF,
with L5 Table Base

Grounding: R56

Axys Control System
User Interface controlled through Windows, Android,
and IOS Fan

Heat: (2) 250w Forced Air Heaters
Task Light: (2) Dimmable lights with flexible mounting
arm on keyboard surface.
Footwell Lighting
Down Bias Lighting
Arc Lighting
Status Light: (3) High with Red, Yellow, Green LED's

36" W CPU Cabinet under Flip Top Worksurface:
front locking doors, internal fixed shelf,
(2) silent 45 CFM fans for active ventilation.
CPU's Per Position:
(3) 7.5"W x 18"H x 18"D
(1) XX"W x XX"H x XX"D

Cable Management Bridge: Cable organization from
desk to CPU Cabinet

"Rollervision" Monitor Mounting System: 10" focal depth
adjustment, accommodates the following monitors left to right:
Top Row: 24", 24", 24"
Bottom Row: 24" on scissor arm, 24", 24", 24" on scissor arm

Datadock: Keyboard surface cable organizer, accommodates
the following: (8) USB Ports & (1) CAT6 Port

Single Metal Shelf: Under monitor surface, with grommet & (1) Power-
only USB, (1) USB-C and (1) Power Outlet. 19"W x 5 1/4"H x 9"D

10"H Smoked Acrylic

18"W Storage Cabinet: Adjustable shelf, lockable front doors,
30" AFF to top side of worksurface

Power & Data Grommet: (2) Power Outlets, (1) USB Charge,
(1) USB-C Charge, (1) CAT6 & (1) HDMI on worksurface

42"H Panel System: .55NRC Rated sound absorption
* 3D Laminate Exterior Top & Bottom Tiles

Xybix 84"x84" Dual Surface Console:
Sit to stand adjustment range of 22"-48" AFF,
with L5 Table Base

Grounding: R56

Axys Control System
User Interface controlled through Windows, Android,
and IOS Fan

Heat: (2) 250w Forced Air Heaters
Task Light: (2) Dimmable lights with flexible mounting
arm on keyboard surface.
Footwell Lighting
Down Bias Lighting
Arc Lighting
Status Light: (3) High with Red, Yellow, Green LED's

10"H Smoked Acrylic

48"H Panel System: .55NRC Rated sound absorption

"Rollervision" Monitor Mounting System: 10" focal depth
adjustment, accommodates the following monitors left to right:
Top Row: 24", 24", 24"
Bottom Row: 24" on scissor arm, 24", 24", 24" on scissor arm

Power & Data Grommet: (2) Power Outlets, (1) USB Charge,
(1) USB-C Charge, (1) CAT6 & (1) HDMI on worksurface

Single Metal Shelf: Under monitor surface, with grommet & (1) Power-
only USB, (1) USB-C and (1) Power Outlet. 19"W x 5 1/4"H x 9"D

18"W Drawer Pedestal: 6", 6", 12" drawers

Datadock: Keyboard surface cable organizer, accommodates
the following: (8) USB Ports & (1) CAT6 Port

Cable Management Bridge: Cable organization from
desk to CPU Cabinet

18"W x 48"H TechTower CPU Cabinet: front & side locking
doors, (2) internal fixed shelves, (2) silent 45 CFM fans for active
ventilation.

CPU's Per Position:
(3) 7.5"W x 18"H x 18"D
(1) XX"W x XX"H x XX"D

**** OTHER DISPATCH ****
(2) **18"W CPU Cabinet under Flip Top Worksurface:**
front locking doors, internal fixed shelf,
(2) silent 45 CFM fans for active ventilation.

CPU's Per Position:
(3) 7.5"W x 18"H x 18"D
(1) XX"W x XX"H x XX"D

Xybix 90"x44" Dual Surface Console:
Sit to stand adjustment range of 22"-48" AFF,
with L5 Table Base

Grounding: R56

Axys Control System
User Interface controlled through Windows, Android,
and IOS Fan

Heat: (2) 250w Forced Air Heaters
Task Light: (2) Dimmable lights with flexible mounting
arm on keyboard surface.
Footwell Lighting
Down Bias Lighting
Arc Lighting
Status Light: (3) High with Red, Yellow, Green LED's

18"W x 48"H TechTower CPU Cabinet:
front & side locking doors, (2) internal fixed shelves,
(2) silent 45 CFM fans for active ventilation.

CPU's Per Position:
(3) 7.5"W x 18"H x 18"D
(1) XX"W x XX"H x XX"D

Cable Management Bridge: Cable organization from
desk to CPU Cabinet

"Rollervision" Monitor Mounting System: 10" focal depth
adjustment, accommodates the following monitors left to right:
Top Row: 24", 24", 24"
Bottom Row: 24" on scissor arm, 24", 24", 24"

10"H Smoked Acrylic

Single Metal Shelf: Under monitor surface, with grommet & (1) Power-
only USB, (1) USB-C and (1) Power Outlet. 19"W x 5 1/4"H x 9"D



Datadock: Keyboard surface cable organizer, accommodates
the following: (8) USB Ports & (1) CAT6 Port

Power & Data Grommet: (2) Power Outlets, (1) USB Charge,
(1) USB-C Charge, (1) CAT6 & (1) HDMI on worksurface



Single Adjustable Monitor Arm: Accommodates (1) 24" monitor

33.25"W Drawer Pedestal & Bookcase Combo:
6", 12", 12" drawers, 15.25"W bookcase



48"H Panel System: .55NRC Rated sound absorption

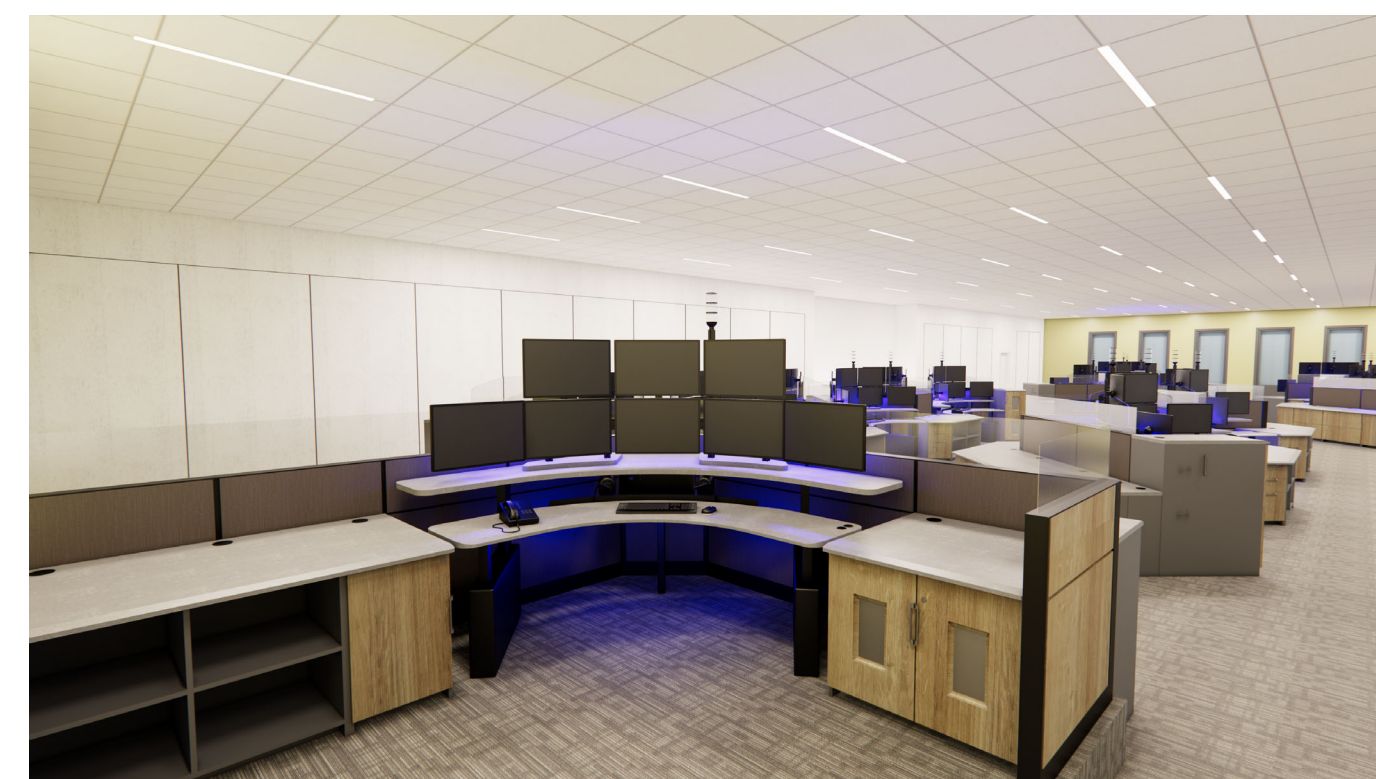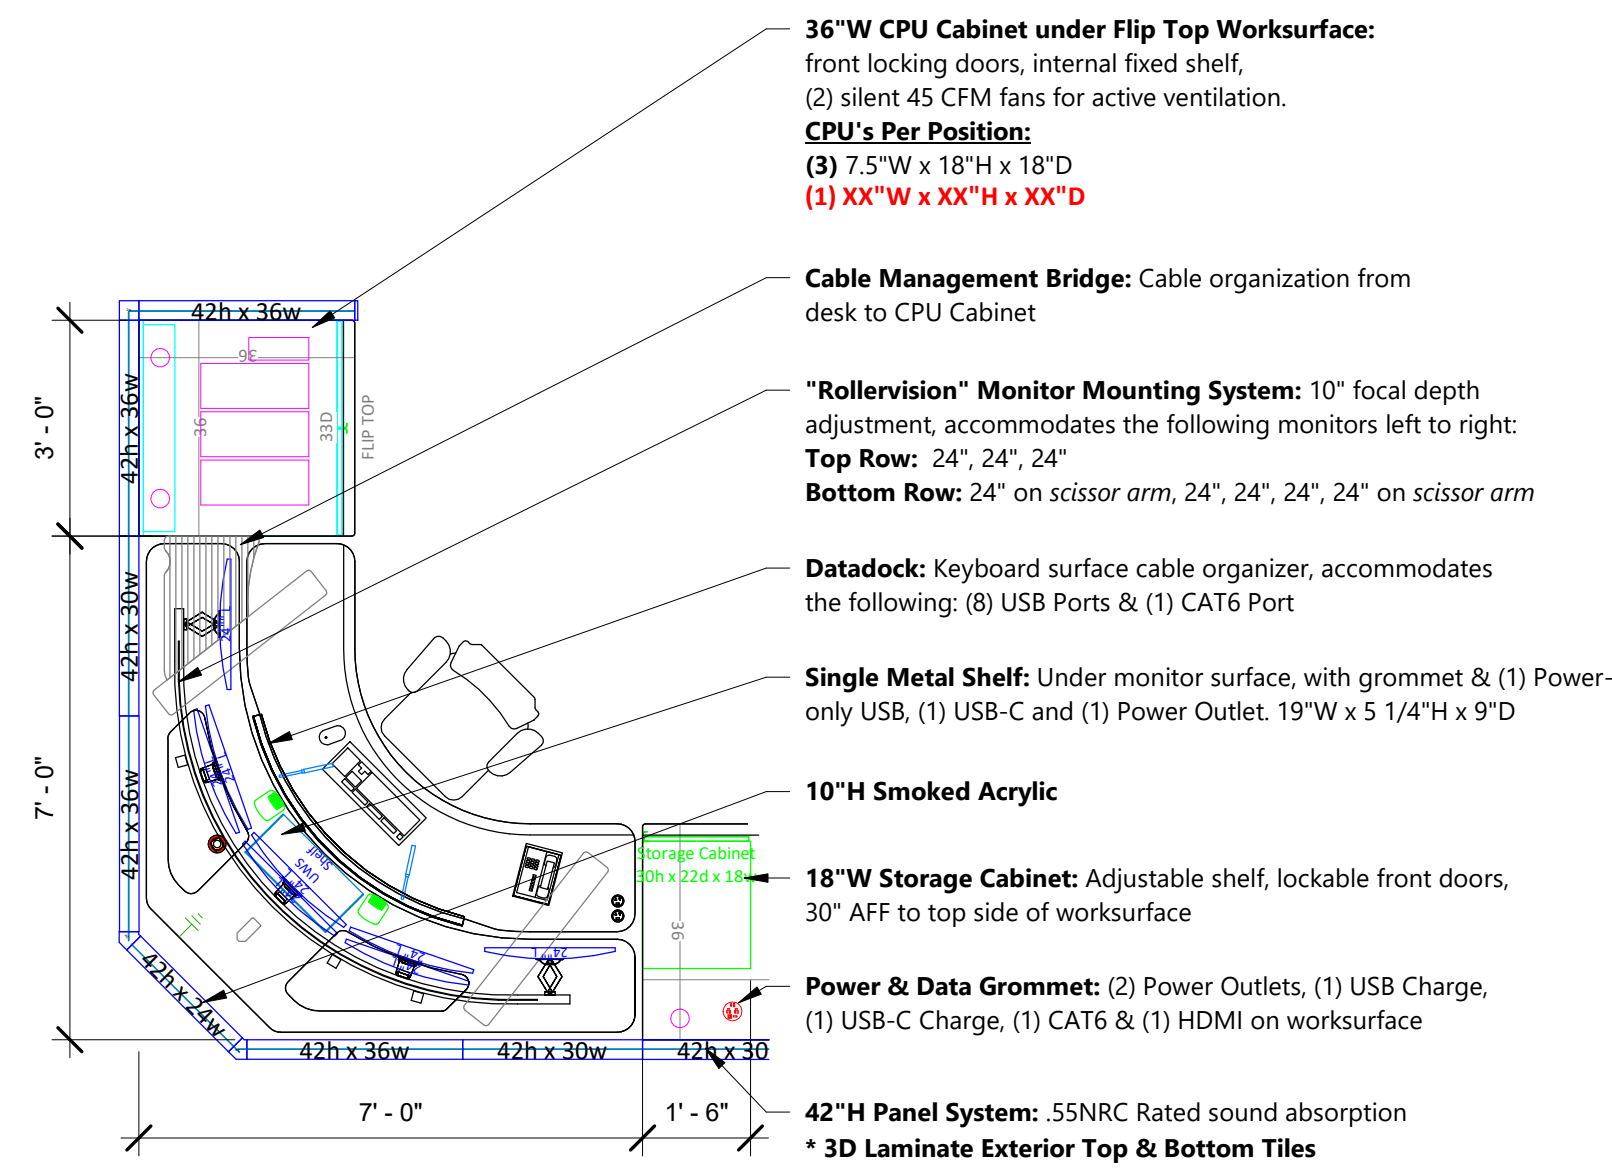

① TYPICAL CURVED - SUPERVISOR
3/8" = 1'-0"

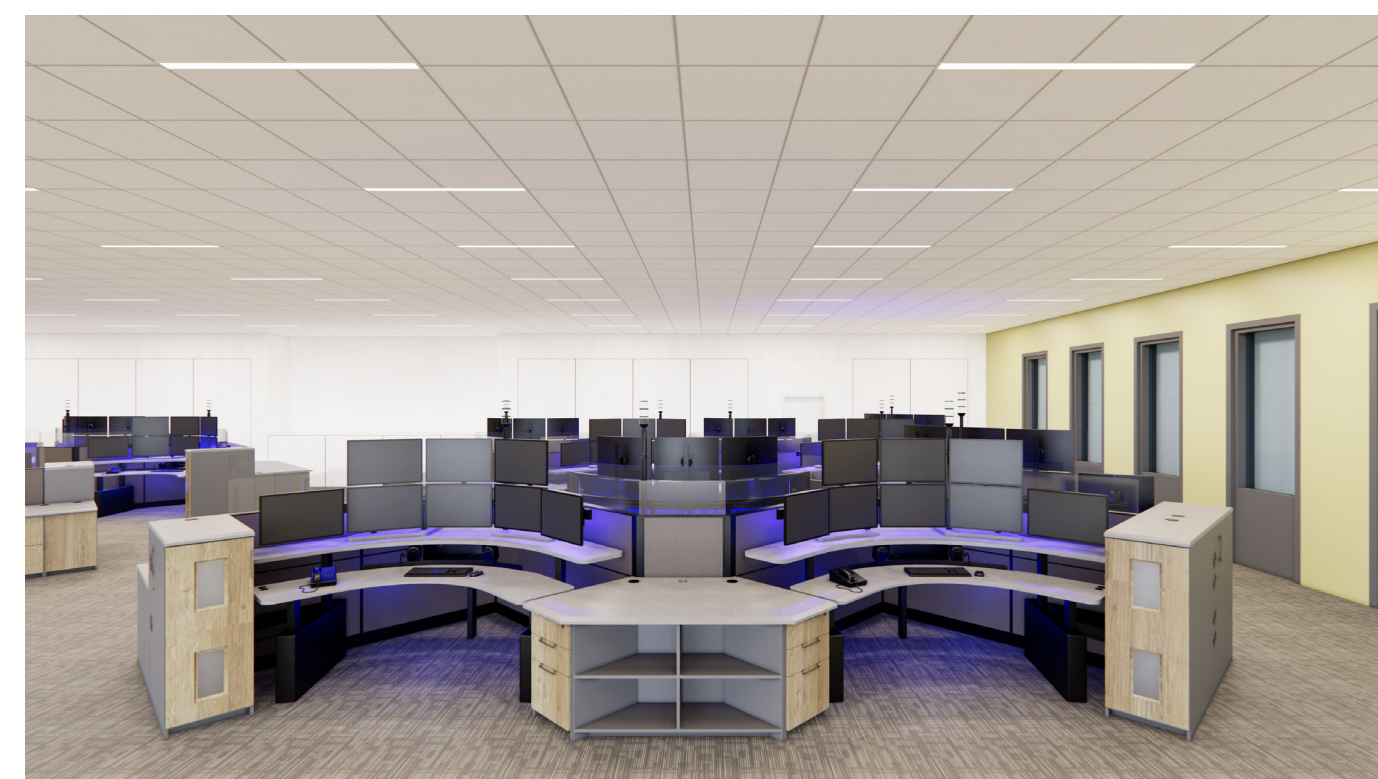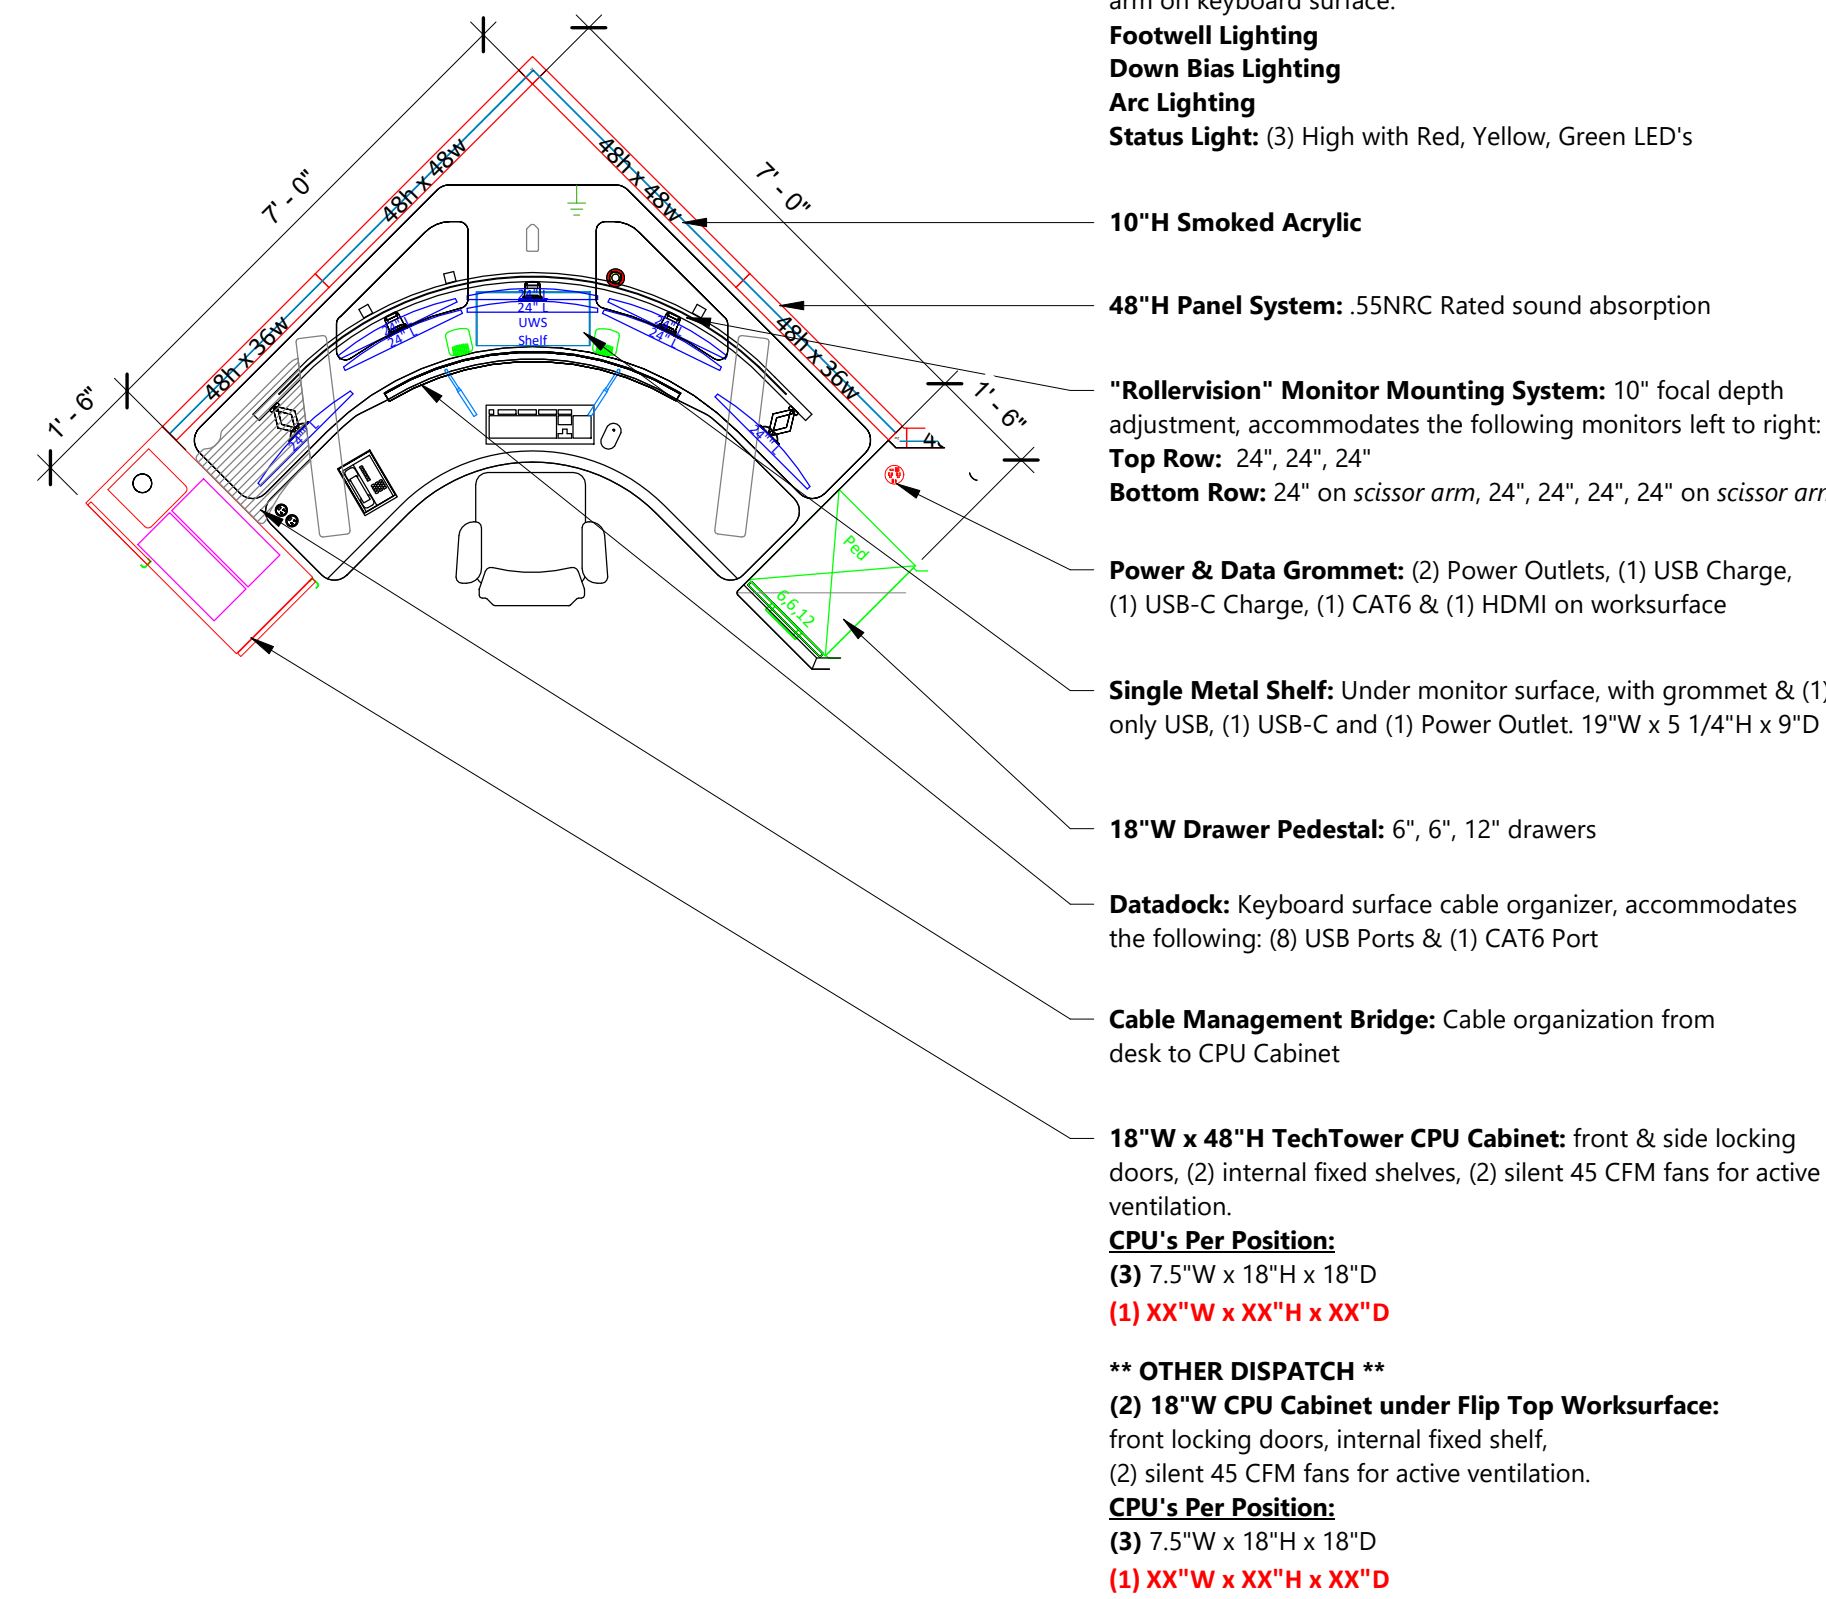

② TYPICAL CURVED - DISPATCH
3/8" = 1'-0"

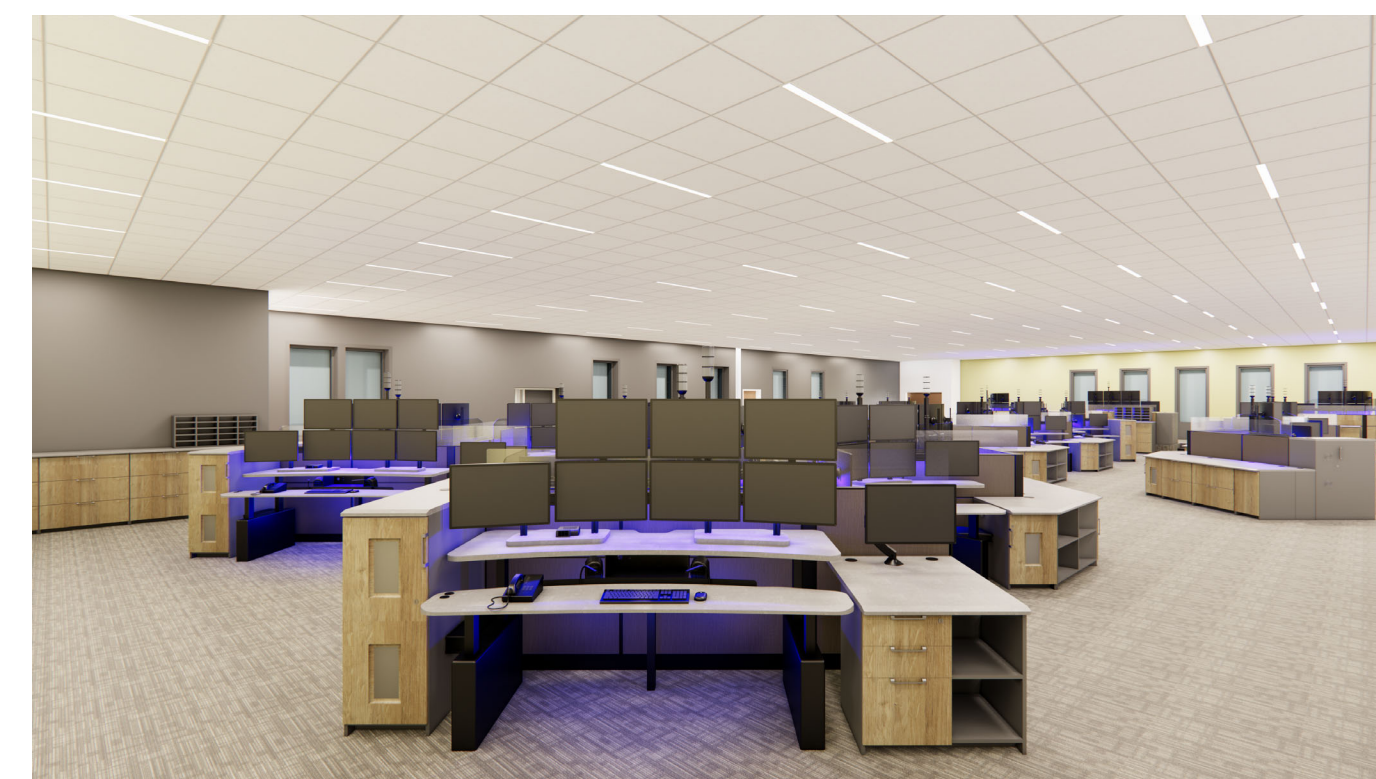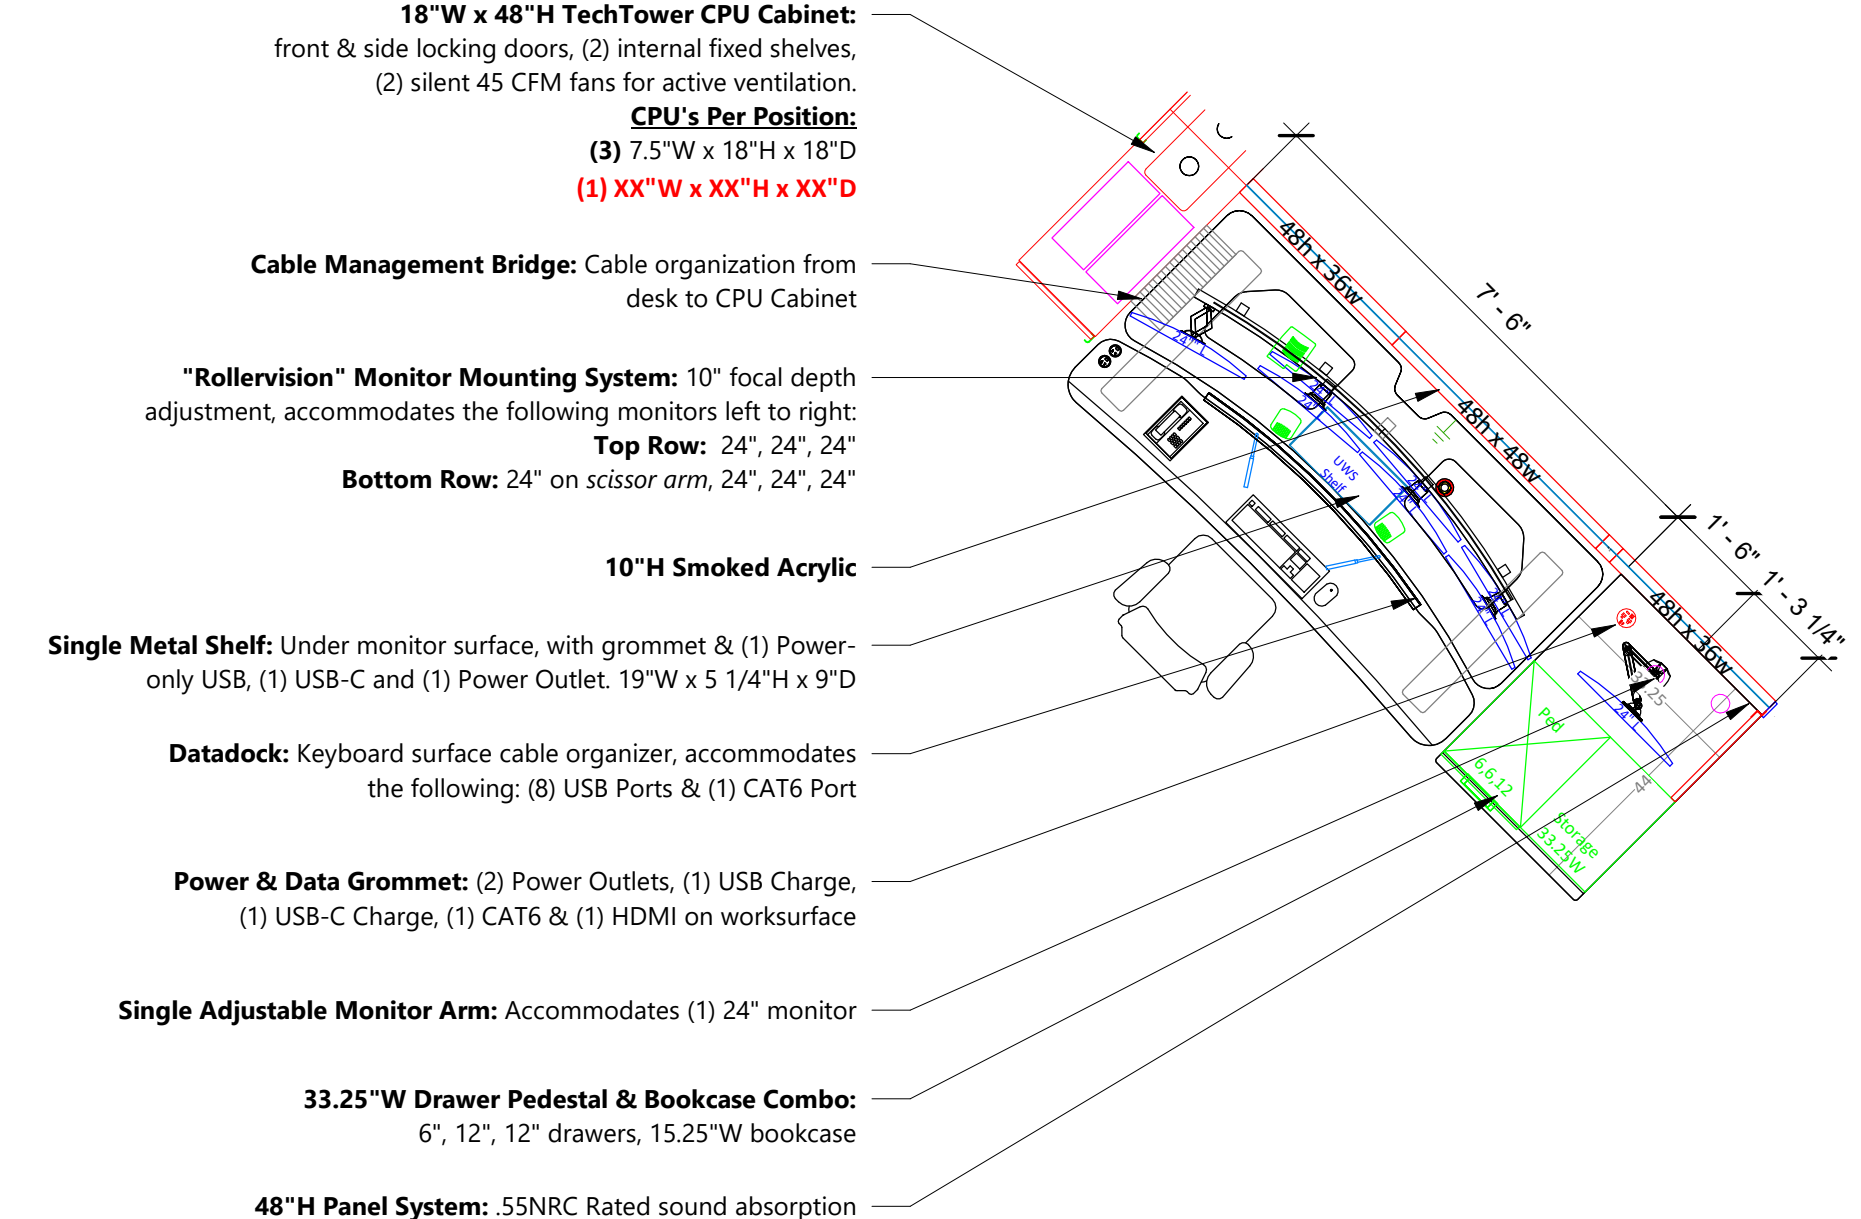

③ TYPICAL STRAIGHT
3/8" = 1'-0"

Opportunity: 0026249

Carpet Opp: N/A

Drawing Name:


TYPICALS

SHEET: D3.0 SCALE: As indicated

NOTE: This design & layout is the property of XYBIX Systems, Inc. & is not to be used in any written manner without express written permission by XYBIX Systems, Inc.

Sign-Off Initials: REV 6

REV	DESCRIPTION	DATE	DESIGNER
3	Updated Zigzag (4) rows of (2) and SUP Platform.	12.21.22	MND
4	Left side of room to have (3) horizontal zig zags of (4) - Straight station on left end; right side of room to have (4) horizontal zig zags - top (3) with (4) - bottom of (6) curved; SUP 2nd opening ramp up in middle - move storage	2.28.23	MND
5	48H Panels: Acrylic to be frosted; Remove Cup Holders; Cables determined	08.31.23	MND
6	All workstation items approved; Finishes selected; Cables determined	09.18.23	MND

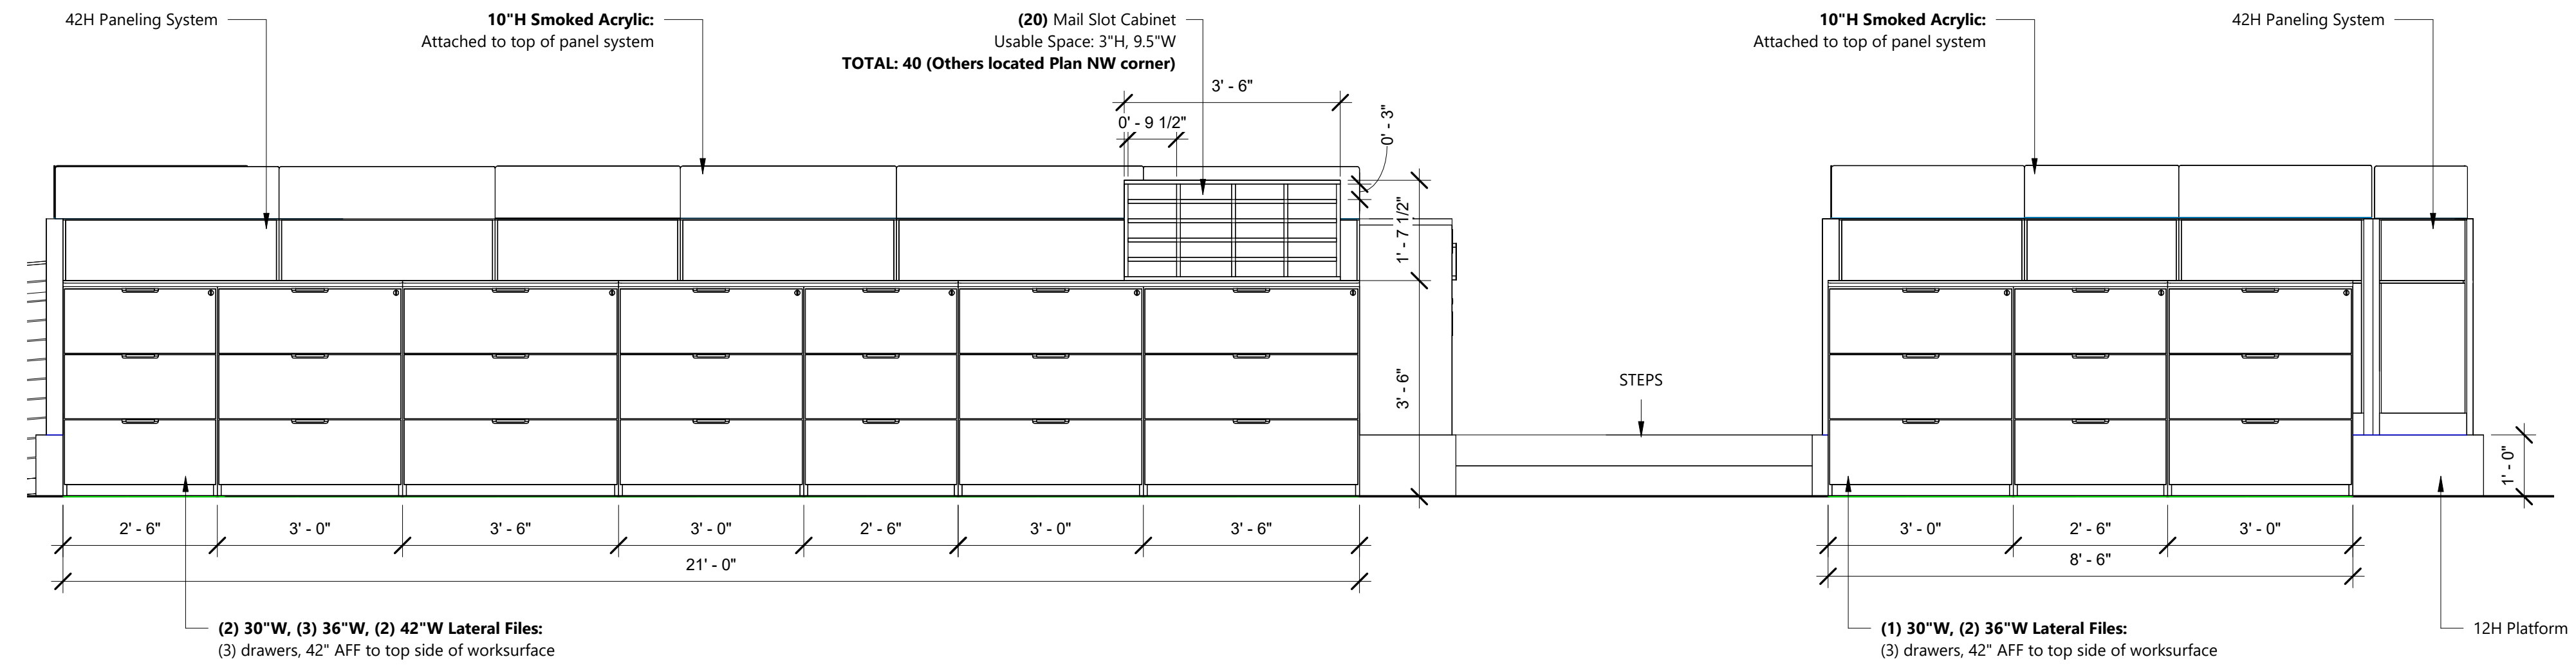

① IN FRONT OF SUPERVISOR STORAGE
1/2" = 1'-0"

Opportunity: 0026249

Carpet Opp: N/A

Drawing Name:
ELEVATIONS

SHEET: D4.0 SCALE: As indicated

NOTE: This design & layout is the property of XYBIX Systems, Inc. & is not to be used in any written manner without express written permission by XYBIX Systems, Inc.

Sign-Off Initials: REV 6


DESIGNER	MND
MND	MND

DATE	12.21.22	2.28.23	08.31.23	09.18.23
MND	MND	MND	MND	MND


REV	DESCRIPTION
3	Updated Zigzag (4) rows of (2) and SUP Platform. Left side of room to have (3) horizontal zig zags of (4) - Straight station on left end; Right side of room to have (4) horizontal zig zags - top (3) with (4) - bottom of (6) curved. SUP 2nd opening ramp up in middle - move storage
4	48H Panels, Acrylic to be frosted. Remove Cup Holders. Cables determined
5	All workstation items approved. Finishes selected. Cables determined
6	All workstation items approved. Finishes selected. Cables determined



① PLAN NW STORAGE
1/2" = 1'-0"

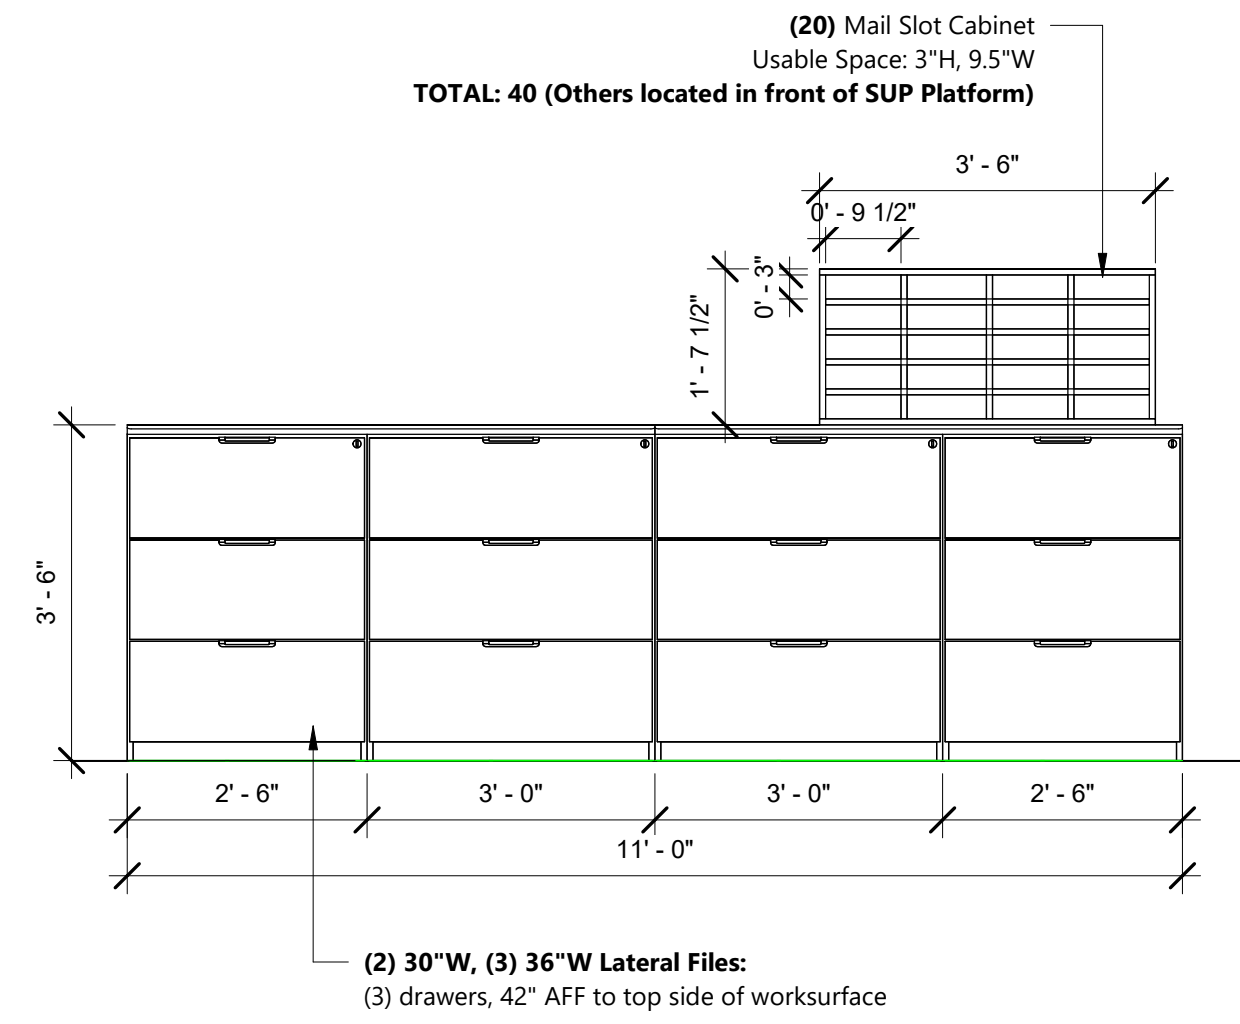

② ZIGZAG END STORAGE
1/2" = 1'-0"

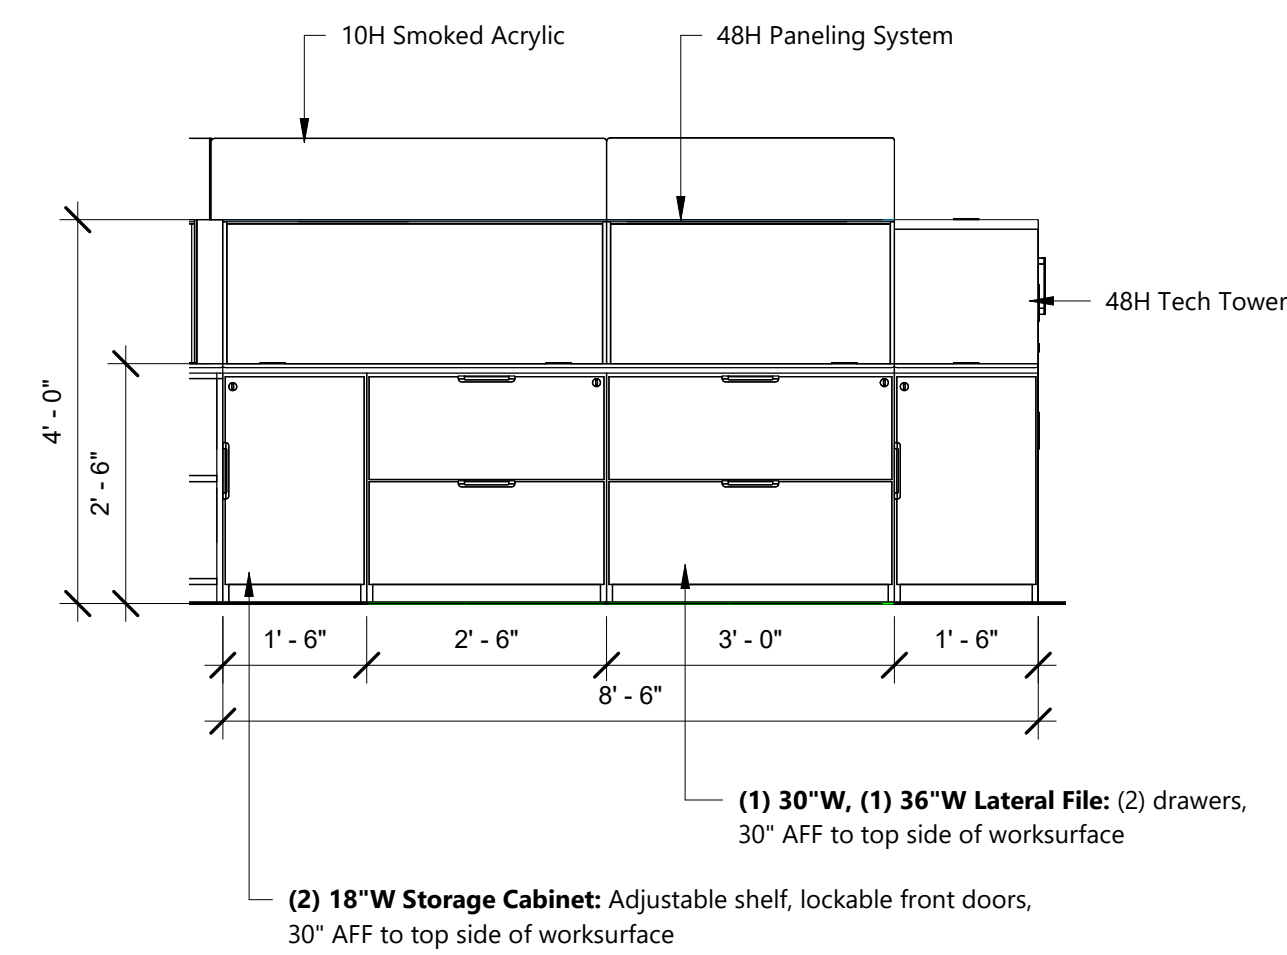

Opportunity: 0026249

Carpet Opp: N/A

Drawing Name:
ELEVATIONS


SHEET: D4.1 SCALE: As indicated

NOTE: This design & layout is the property of XYBIX Systems, Inc. & is not to be used in any written manner without express written permission by XYBIX Systems, Inc.

Sign-Off Initials: REV 6

REV	DESCRIPTION	DATE	DESIGNER
3	Updated Zigzag (4) rows of (2) and SUP Platform.	12.21.22	MND
4	Left side of room to have (3) horizontal zig zags of (4) - Straight station on left end; Right side of room to have (4) horizontal zig zags - top (3) with (4) - bottom of (6) curved; SUP 2nd opening ramp up in middle - move storage	2.28.23	MND
5	48H Panels, Acrylic to be frosted; Remove Cup Holders; Cables determined	08.31.23	MND
6	All workstation items approved; Finishes selected; Cables determined	09.18.23	MND

FINISH LOCATIONS

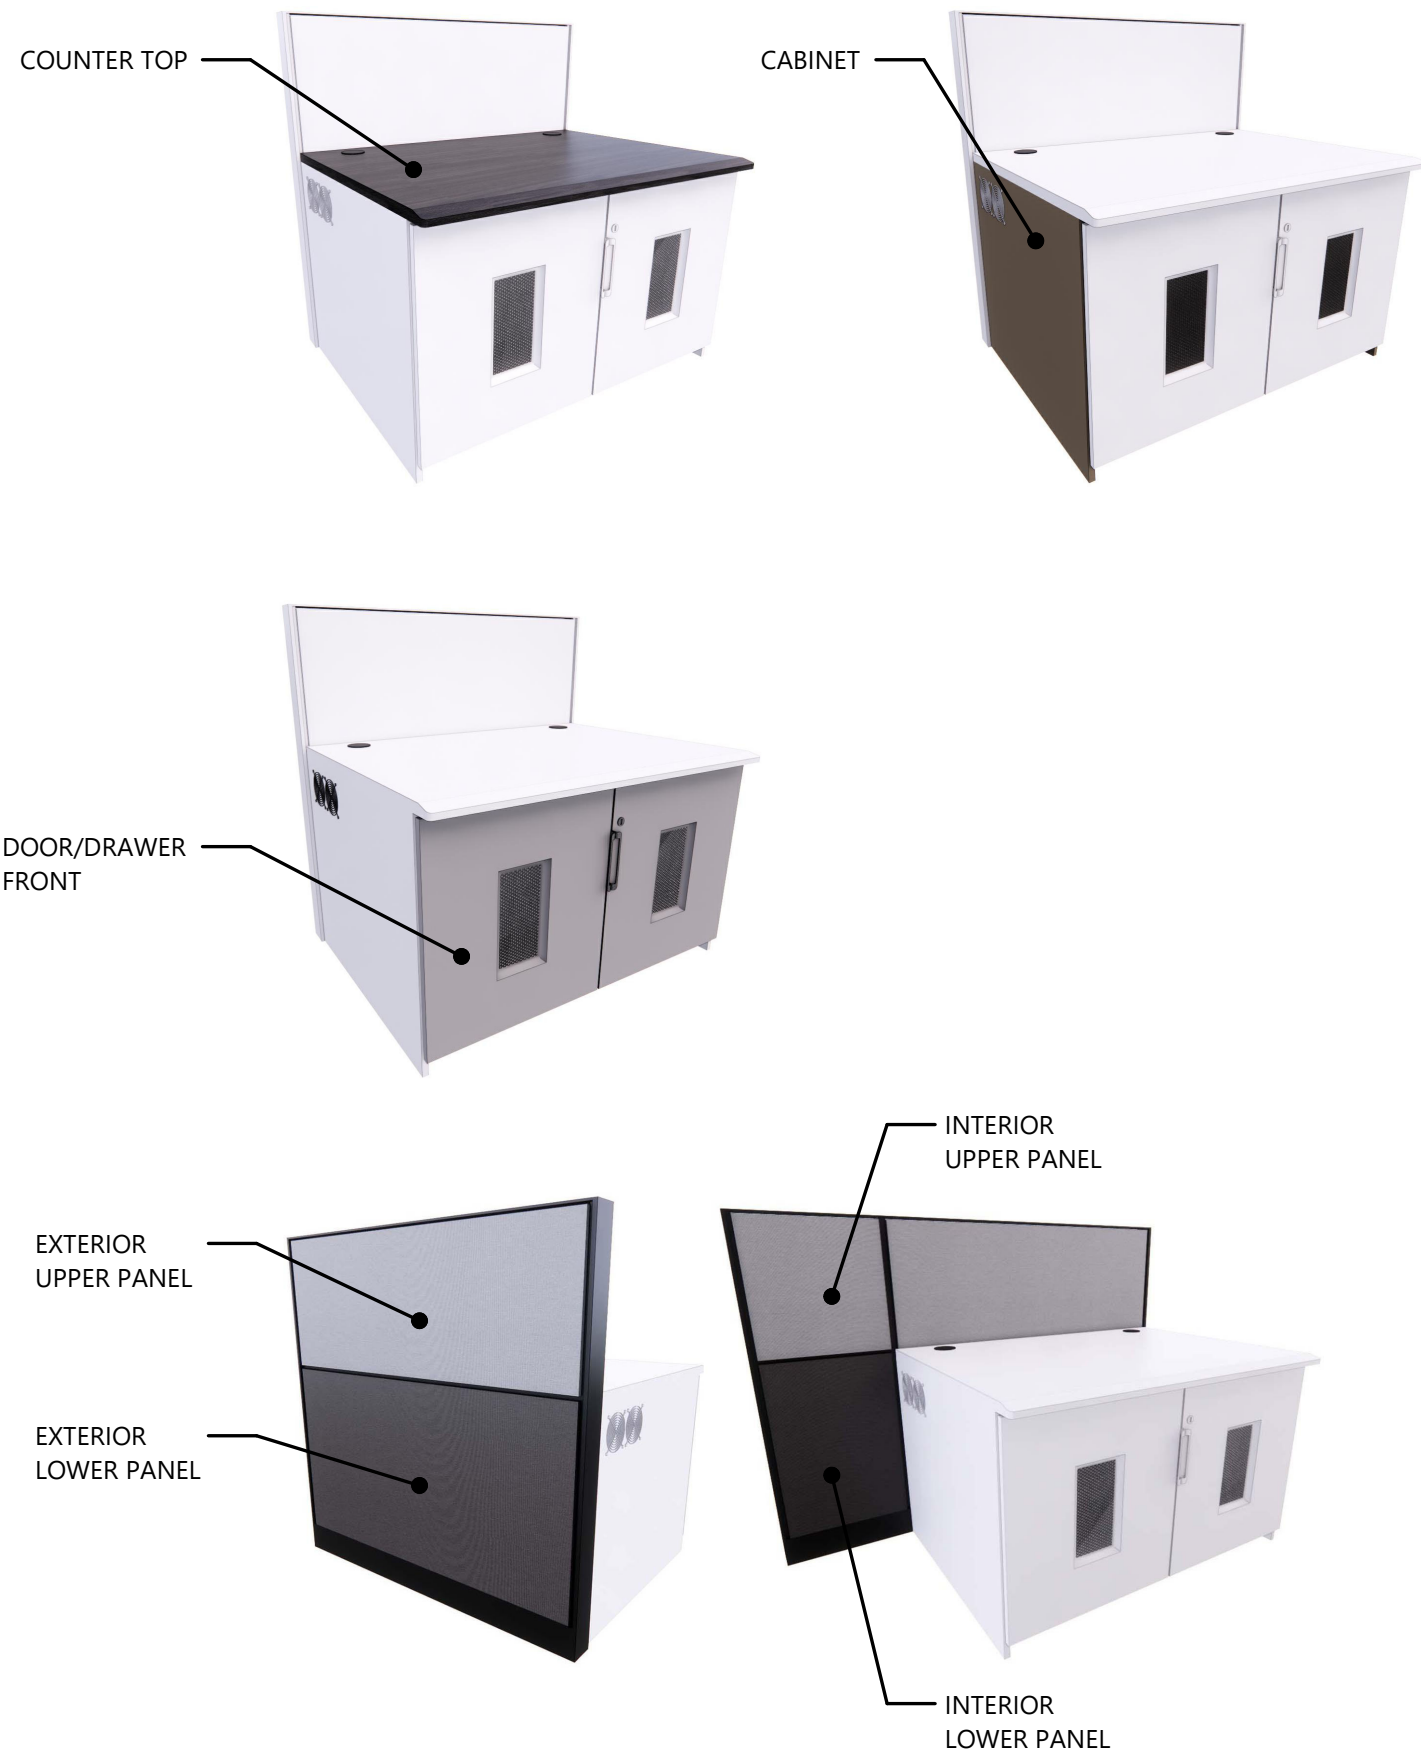




FINISH SELECTIONS

Panel Trim : Black
 Interior Upper Panel : CF Stinson Binary Toasted BIN58
 Interior Lower Panel : CF Stinson Binary Toasted BIN58
 Exterior Upper Panel : Dackor Riviera Oak, Mistral D097
 Exterior Lower Panel : Dackor Riviera Oak, Mistral D097
 Counter Top : Dackor Sahara Stone A020
 Door & Drawer Front : Dackor Riviera Oak, Mistral D097
 Cabinet : Panolam Storm TFL S565
 Edgeband : Panolam Storm TFL match
 Handle : Eagle Silver

<u>Interior Upper Panel</u>  BINARY TOASTED	<u>Exterior Upper Panel</u>  RIVIERA OAK MISTRAL	<u>Counter Top</u>  SAHARA STONE	<u>Handle</u>  SILVER
<u>Interior Lower Panel</u>  BINARY TOASTED	<u>Exterior Lower Panel</u>  RIVIERA OAK MISTRAL	<u>Cabinet</u>  STORM	<u>Door/Drawer Front</u>  RIVIERA OAK MISTRAL

CARPET SELECTIONS

Carpet : .N/A
 Cove Base : .N/A
 Installation Method : .N/A
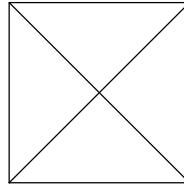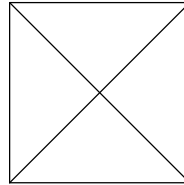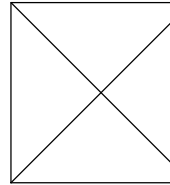
<u>Carpet</u>  N/A	<u>Cove Base</u>  N/A	<u>Installation Method</u>  N/A
---------------------------------------------------------------------------------------------------------------	------------------------------------------------------------------------------------------------------------------	----------------------------------------------------------------------------------------------------------------------------



8207 SouthPark Circle
 Littleton, CO. 80120
 1.800.788.2810 F.303.683.5454
 www.xybix.com

Sales : Amanda Schwartz

Email : AmandaS@xybix.com

Designer : Meghan Dinardi

Email : MeghanD@xybix.com

Lake County Regional 911 PSAP Consolidation
 636 Winchester Rd
 Libertyville, IL 60048

Opportunity: 0026249

Carpet Opp: N/A

Drawing Name:
 FINISH SELECTION

SHEET: 6.0 SCALE: 3/8" = 1'-0"

NOTE: This design & layout is the property of XYBIX Systems, Inc. & is not to be used in any written manner without express written permission by XYBIX Systems, Inc.

Sign-Off Initials: _____ REV 6

CABLE EXTENSIONS (PER POSITION)

POSITION(S) TYPE: CURVED & STRAIGHT



8207 SouthPark Circle
Littleton, CO. 80120
1.800.788.2810 F.303.683.5454
www.xybix.com

Sales : Amanda Schwartz
Email : AmandaS@xybix.com
Designer : Meghan Dinardi
Email : MeghanD@xybix.com

Lake County Regional 911 PSAP Consolidation
636 Winchester Rd
Libertyville, IL 60048

DUAL SURFACE DATADOCK CABLES (For Keyboard, Mouse and Phone connections)



CABLE ADAPTOR TYPE	 DUAL USB (2) (Cable Managed to CPU Cabinet) Keyboard & Mouse	 CHARGE ONLY - DUAL USB (2) (Cable Managed to Power Outlet) Cell Phone charging	 CAT6 (Max. 2) (Cable Managed to CPU Cabinet) Phone ONLY not for Networking	***Datadock has (5) additional slots for expansion if more than (8) USB's and (1) CAT6 is needed. Please note that additional cables will be charged separately.***
QUANTITY	8 Total	N/A	1 Total	

MONITOR SURFACE CABLES

CABLE TYPE	 VGA Male / Female Extension Standard Connection for monitors.	 DVI-D Male / Female Extension Typical for Hi-Resolution	 DVI-I 10' Max Length Male / Female Extension Typical for Hi-Resolution	 HDMI Male / Male Extension Typical for Hi-Resolution
QUANTITY				2 EA.
CABLE TYPE	 Display Port Male / Male Extension Typical for Hi-Resolution	 Display Port to Mini Display Port	 USB	 AUDIO Typical for Speakers
QUANTITY	8 EA.		2 EA.	

KEYBOARD SURFACE CABLES (ONLY applies for Monitor or Touchscreen sitting on Keyboard Surface)

CABLE TYPE	 VGA Male / Female Extension Standard Connection for monitors.	 DVI-D Male / Female Extension Typical for Hi-Resolution	 DVI-I 10' Max Length Male / Female Extension Typical for Hi-Resolution	 HDMI Male / Male Extension Typical for Hi-Resolution	 Display Port Male / Male Extension Typical for Hi-Resolution	 USB Keyboard & Mouse	 CAT6 Phone ONLY
QUANTITY			NONAPPLICABLE				

OPTIONAL ITEMS FOR MONITOR SURFACE (EX: CABLE ADAPTORS, USB'S)

CABLE ADAPTOR TYPE	TO	TO		
QUANTITY				

NONAPPLICABLE

If different cable connector types are required it is your responsibility to contact your Designer or Sales Rep. You agree that any changes to this order following receipt of sign-off drawing and PO may result in additional cost that will be expensed to the client.

Signature: _____


Date: _____

Opportunity: 0026249
Carpet Opp: N/A
Drawing Name:
CABLE SHEET

SHEET: 7.0
SCALE:

NOTE: This design & layout is the property of XYBIX Systems, Inc. & is not to be used in any written manner without express written permission by XYBIX Systems, Inc.

Sign-Off Initials: _____
REV
6

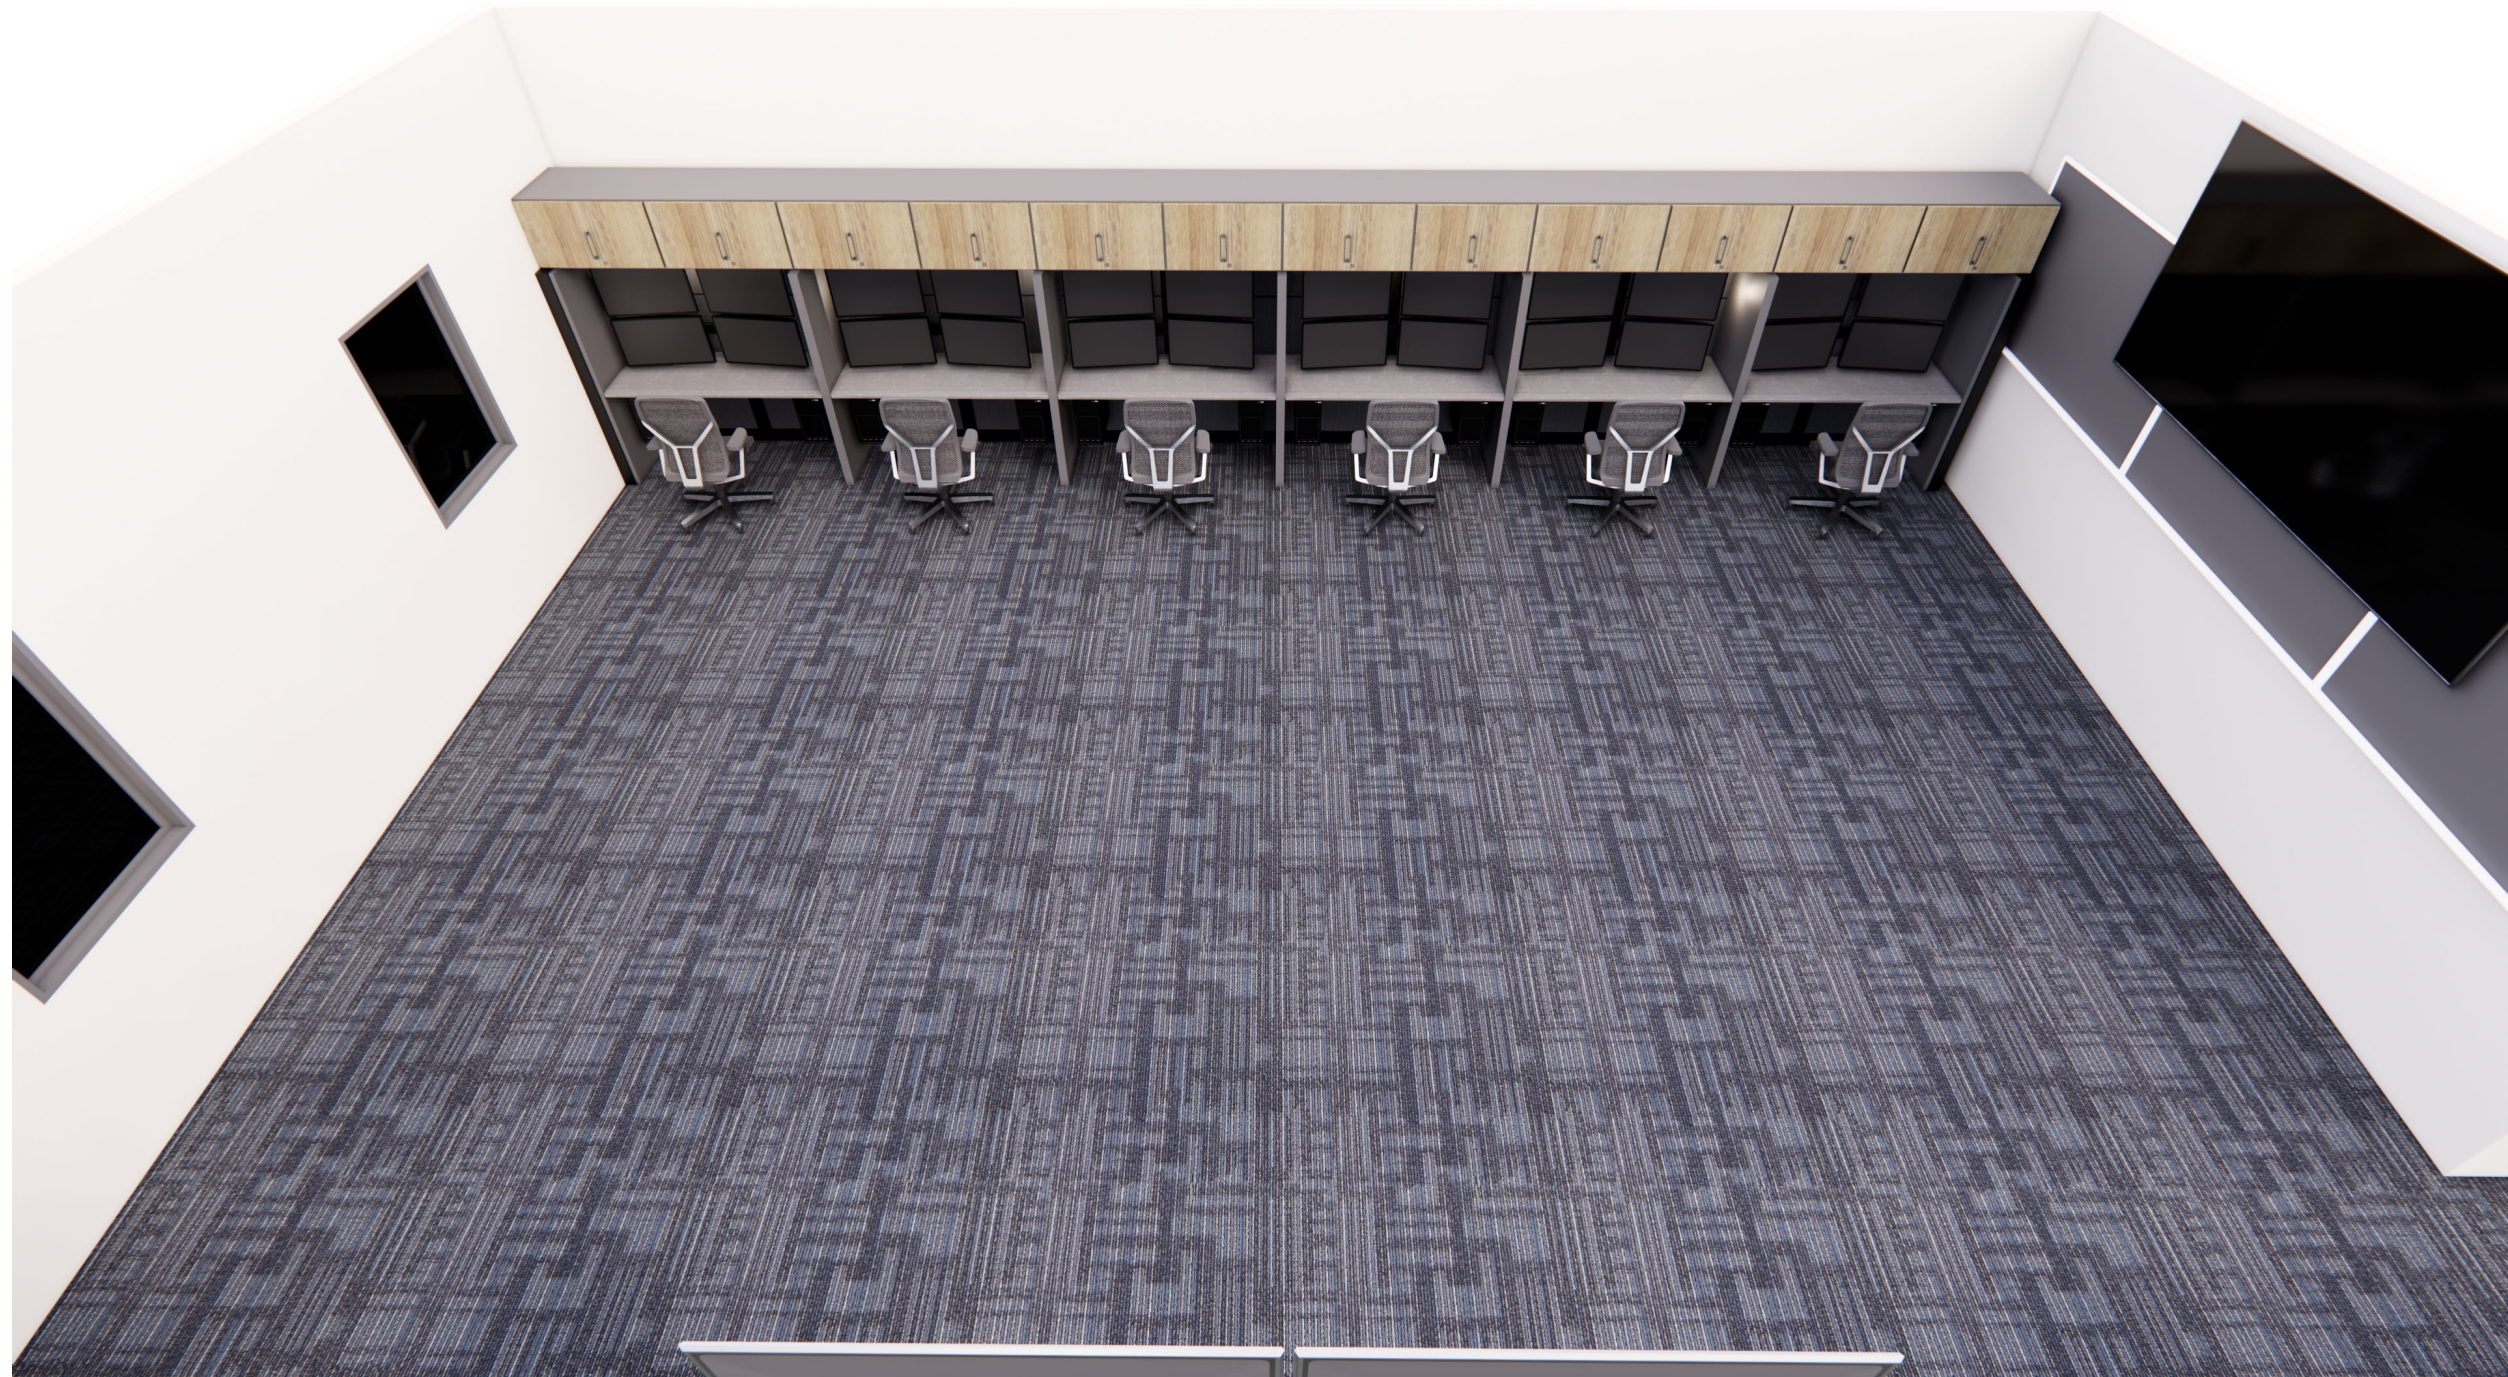

8207 SouthPark Circle
 Littleton, CO. 80120
 1.800.788.2810 F.303.683.5454
 www.xybix.com

Sales : Amanda Schwartz

Email : AmandaS@xybix.com

Designer : Meghan Dinardi

Email : MeghanD@xybix.com

Lake County Regional 911 Backup Center
 636 Winchester Rd
 Libertyville, IL 60048

Opportunity: 0027369

Carpet Opp: N/A

Drawing Name:
 COVER PAGE

SHEET: 1.0 SCALE: 12" = 1'-0"

NOTE: This design & layout is the property of XYBIX Systems, Inc. & is not to be used in any written manner without express written permission by XYBIX Systems, Inc.

Sign-Off Initials:

REV

x_____

3

TABLE OF CONTENTS	
PAGE #	PAGE NAME
1.0	COVER PAGE
2.0	FLOOR PLAN
3.0	TYPICALS
4.0	ELEVATIONS
10.0	FINISH SELECTION
11.0	CABLE SHEET
D8.0	PANEL PLAN

REVISIONS					
REV	DESCRIPTION	DATE	DESIGNER		
0	Drawing Creation	04.03.23	MND		
1	Remove: Nesting Tables & Podium	04.10.23	MND		
2	Update to 6 positions; Monitors to be 2 over 2; Total (2) CPU Hangers; Show other Finish option	08.30.23	MND		
3	Remove retractable/folding doors; Original Finish selection chosen; Cables determined; Remove soffit	09.19.23	MND		

SIGN OFF APPROVAL: Furniture orders and product installation shall not proceed until the Client has given approval to these documents. Approval of the Client shall constitute approval of the drawings for contents, scope of work and all dimensions regarded by the Client as being necessary to the use of space, furnishings and equipment. Furniture orders, or product installation authorized by the Client from these documents, shall be interpreted by XYBIX as approval in full to these documents by the Client. Revisions after approval shall result in additional costs.

Signature: _____

Title: _____

Date: _____



8207 SouthPark Circle
 Littleton, CO. 80120
 1.800.788.2810 F.303.683.5454
 www.xybix.com

Sales : Amanda Schwartz

Email : AmandaS@xybix.com

Designer : Meghan Dinardi

Email : MeghanD@xybix.com

Lake County Regional 911 Backup Center
 636 Winchester Rd
 Libertyville, IL 60048

Opportunity: 0027369

Carpet Opp: N/A

Drawing Name:
 FLOOR PLAN

SHEET:
 2.0

SCALE:


NOTE: This design & layout is the property of XYBIX Systems, Inc. & is not to be used in any written manner without express written permission by XYBIX Systems, Inc.

Sign-Off Initials:

REV

x _____

3

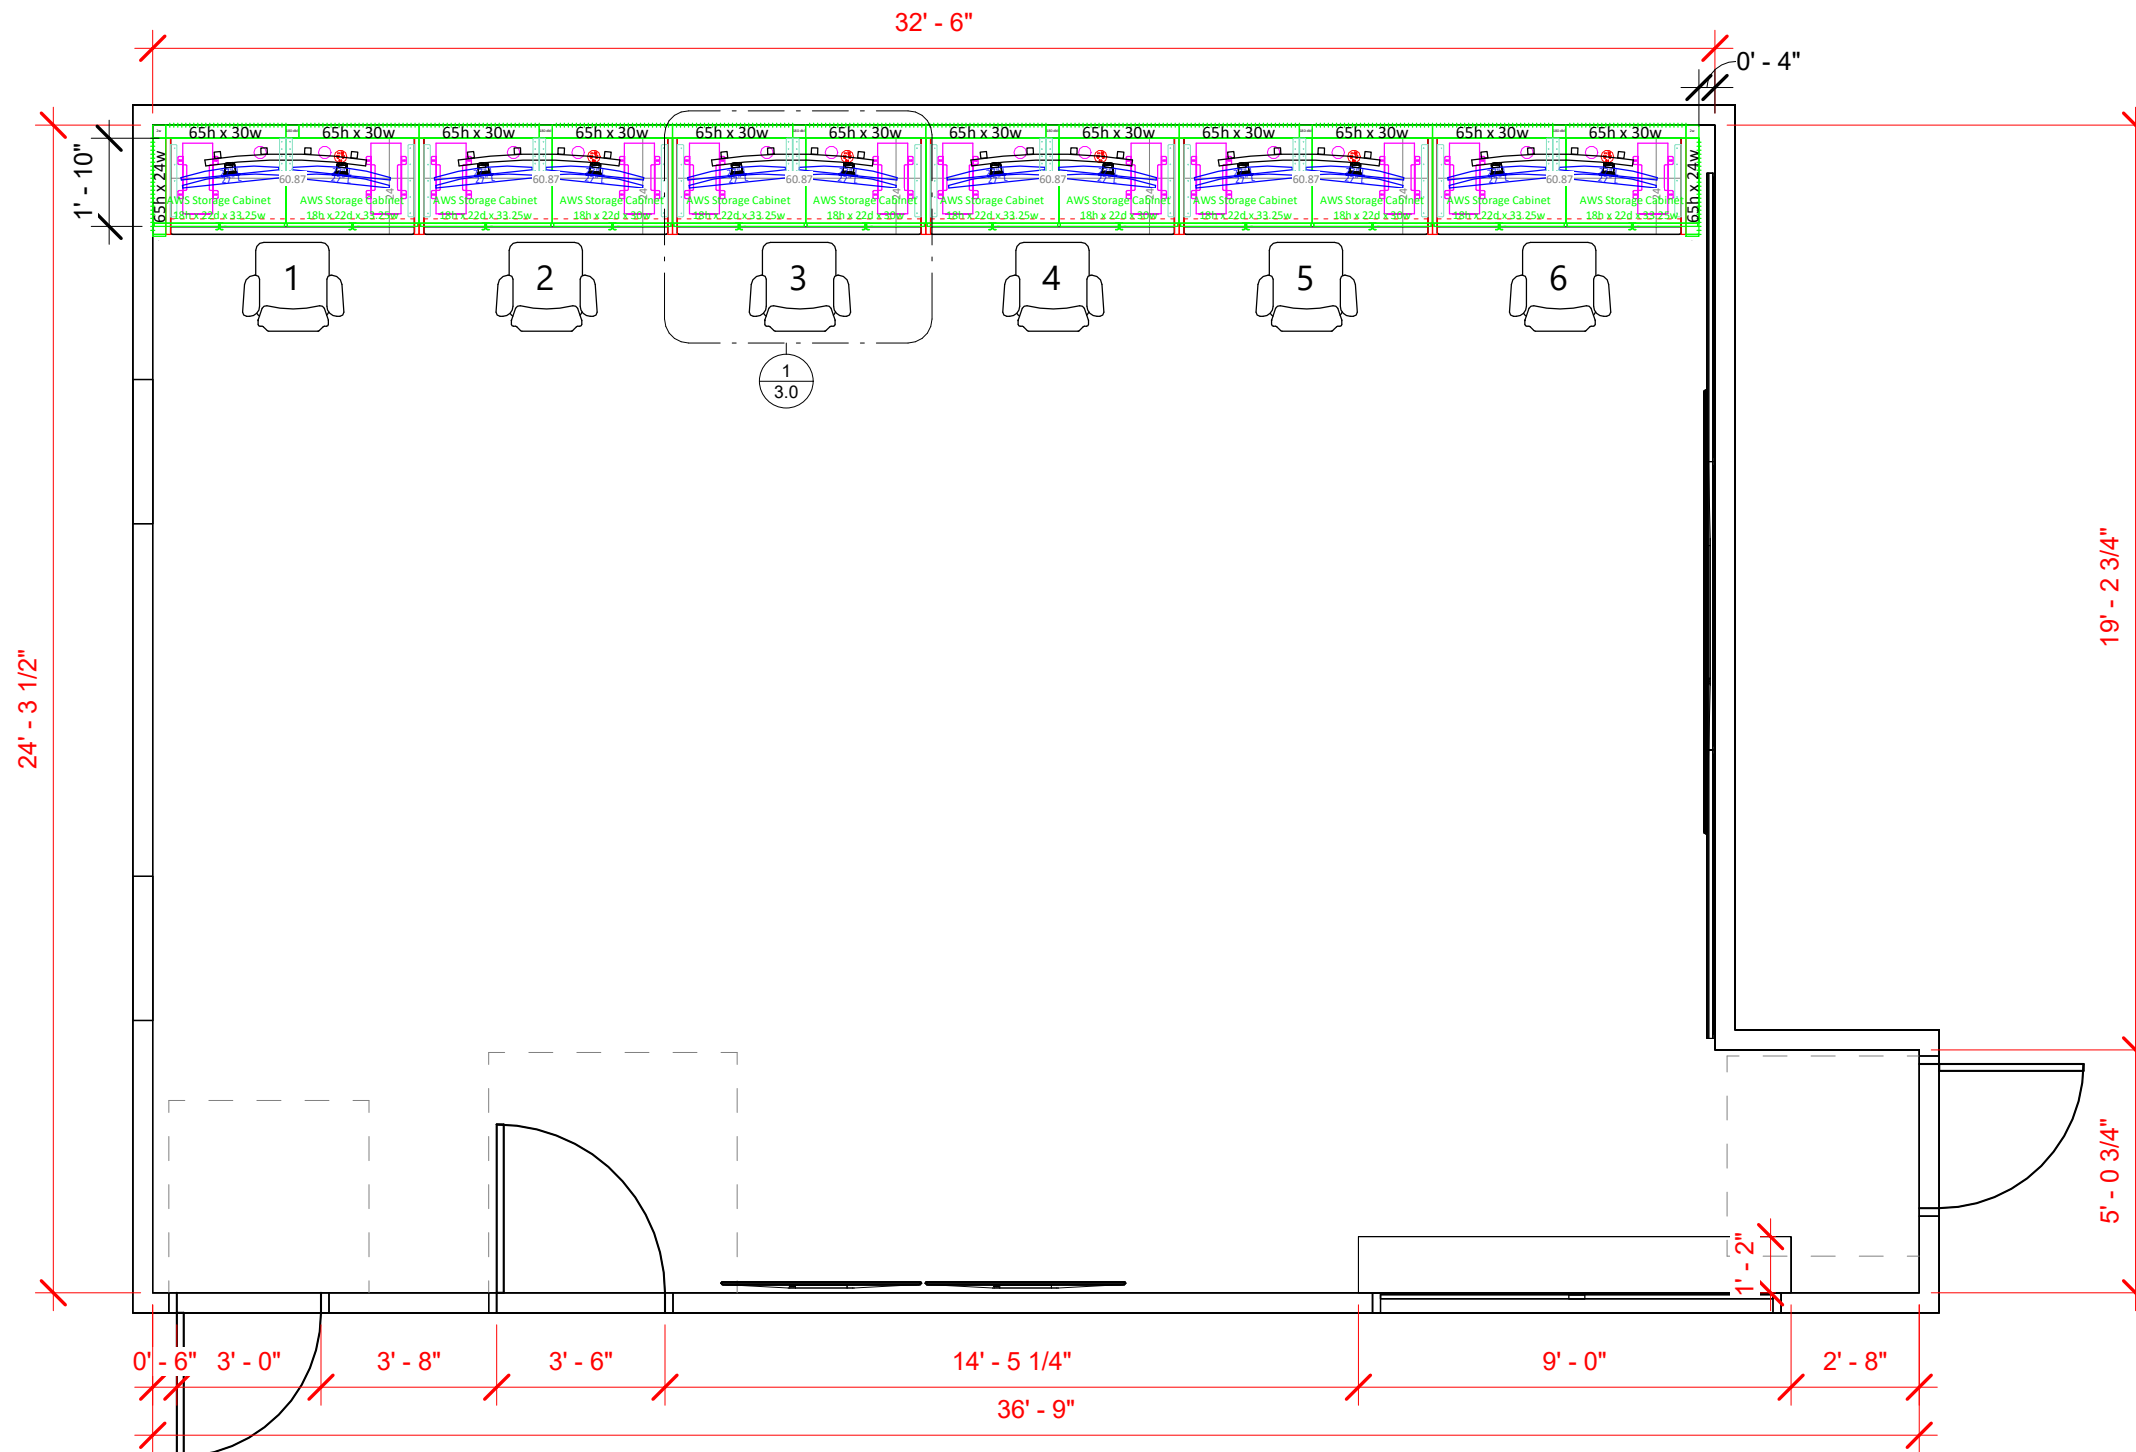

CEILING HEIGHT: ?
 POWER/DATA COMING FROM: WALLS

ALL ROOM DIMENSIONS NEED TO BE VERIFIED
 PRIOR TO INSTALLATION AND SIGN OFF

** TO SHIP AND INSTALL WITH OPP 0026249 **

1 FLOOR PLAN
 1/4" = 1'-0"



Sales : Amanda Schwartz

Email : AmandaS@xybix.com

Designer : Meghan Dinardi

Email : MeghanD@xybix.com

Lake County Regional 911 Backup Center
 636 Winchester Rd
 Libertyville, IL 60048

Opportunity: 0027369

Carpet Opp: N/A

Drawing Name:
 TYPICALS

SHEET:
 3.0

SCALE:

NOTE: This design & layout is the property of XYBIX Systems, Inc. & is not to be used in any written manner without express written permission by XYBIX Systems, Inc.

Sign-Off Initials:

REV

x _____

3



Xybix Fixed Surface Console: 30" AFF

Fixed Monitor Mounting System: Accommodates the following monitors left to right:

Top Row: 27", 27"

Bottom Row: 27", 27"

Note: Placement of mounting system will be determined by customer on site during installation.


Power & Data Grommet: (2) Power Outlets, (1) USB Charge, (1) USB-C Charge, (1) CAT6 & (1) HDMI on worksurface

65"H Panel System: .55NRC Rated sound absorption


(2) CPU Hanger: Mounted under monitor surface, Max. 20"H CPU

33.25"W & 30"W x 18"H Above Storage Cabinet: Adjustable shelf, lockable front doors, 65" AFF to bottom of cabinet **with attached lighting**

J - Channel: Cable organization for under worksurfaces

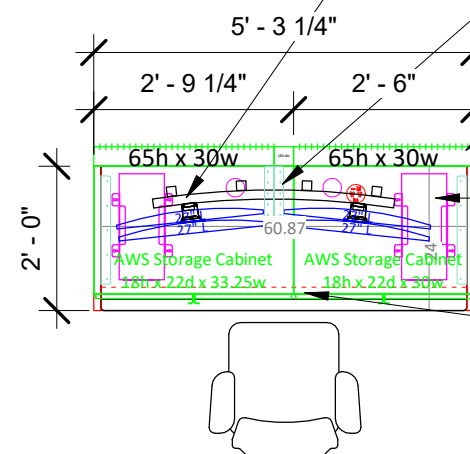

① TYPICAL BACKUP
 3/8" = 1'-0"

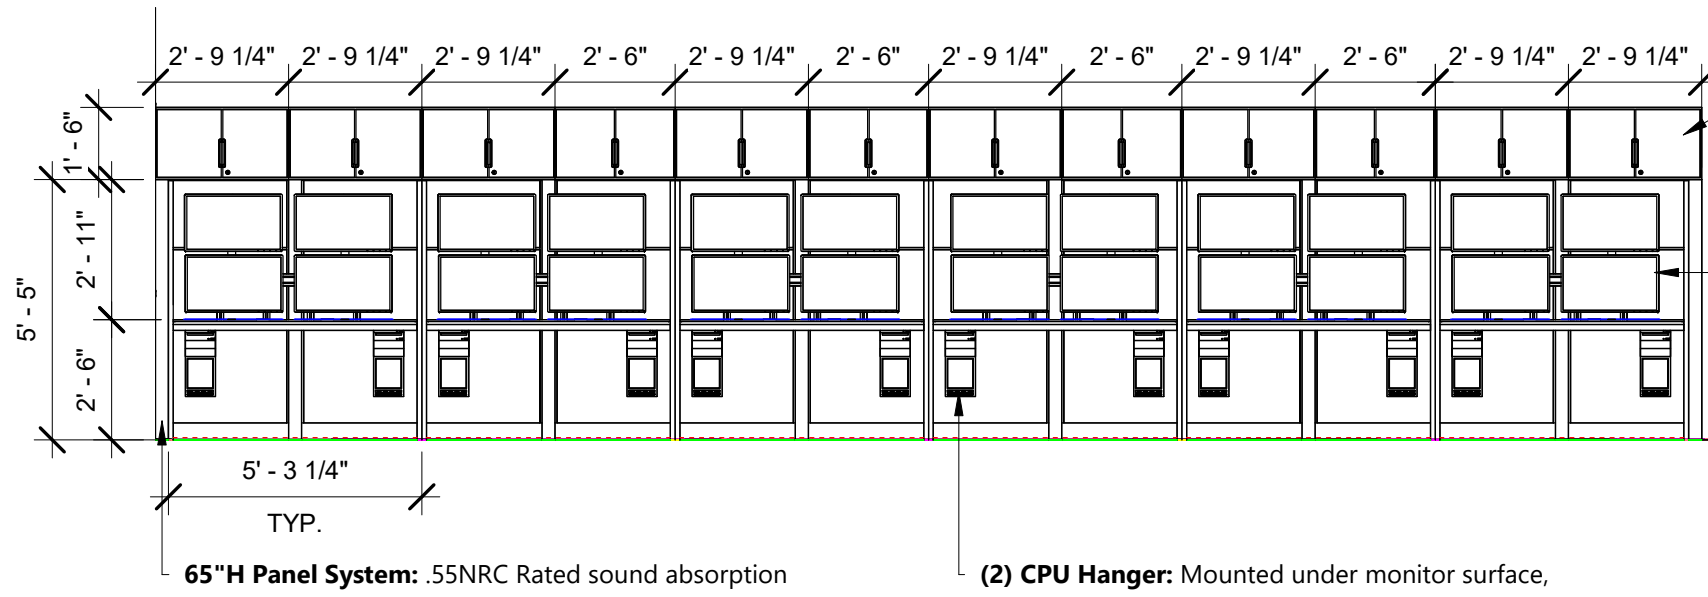

(8) 33.25"W, (4) 30"W x 18"H Above Storage Cabinet:
 Adjustable shelf, lockable front doors with attached lighting
 65" AFF to bottom of cabinet

Fixed Monitor Mounting System: Accommodates the following
 monitors left to right:

Top Row: 27", 27"

Bottom Row: 27", 27"

Note: Placement of mounting system will be determined by customer on site during installation.

(2) CPU Hanger: Mounted under monitor surface,
 Max. 20"H CPU

65"H Panel System: .55NRC Rated sound absorption



① ELEVATION BACKUP
 1/4" = 1'-0"

Opportunity: 0027369

Carpet Opp: N/A


Drawing Name:
 ELEVATIONS

SHEET: 4.0
 SCALE:

NOTE: This design & layout is the property of XYBIX Systems, Inc. & is not to be used in any written manner without express written permission by XYBIX Systems, Inc.




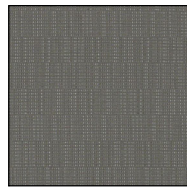
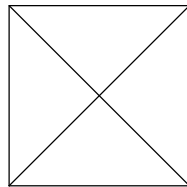

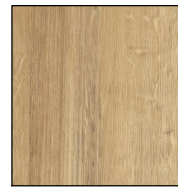
Sign-Off Initials: x_____
 REV
 3

FINISH LOCATIONS

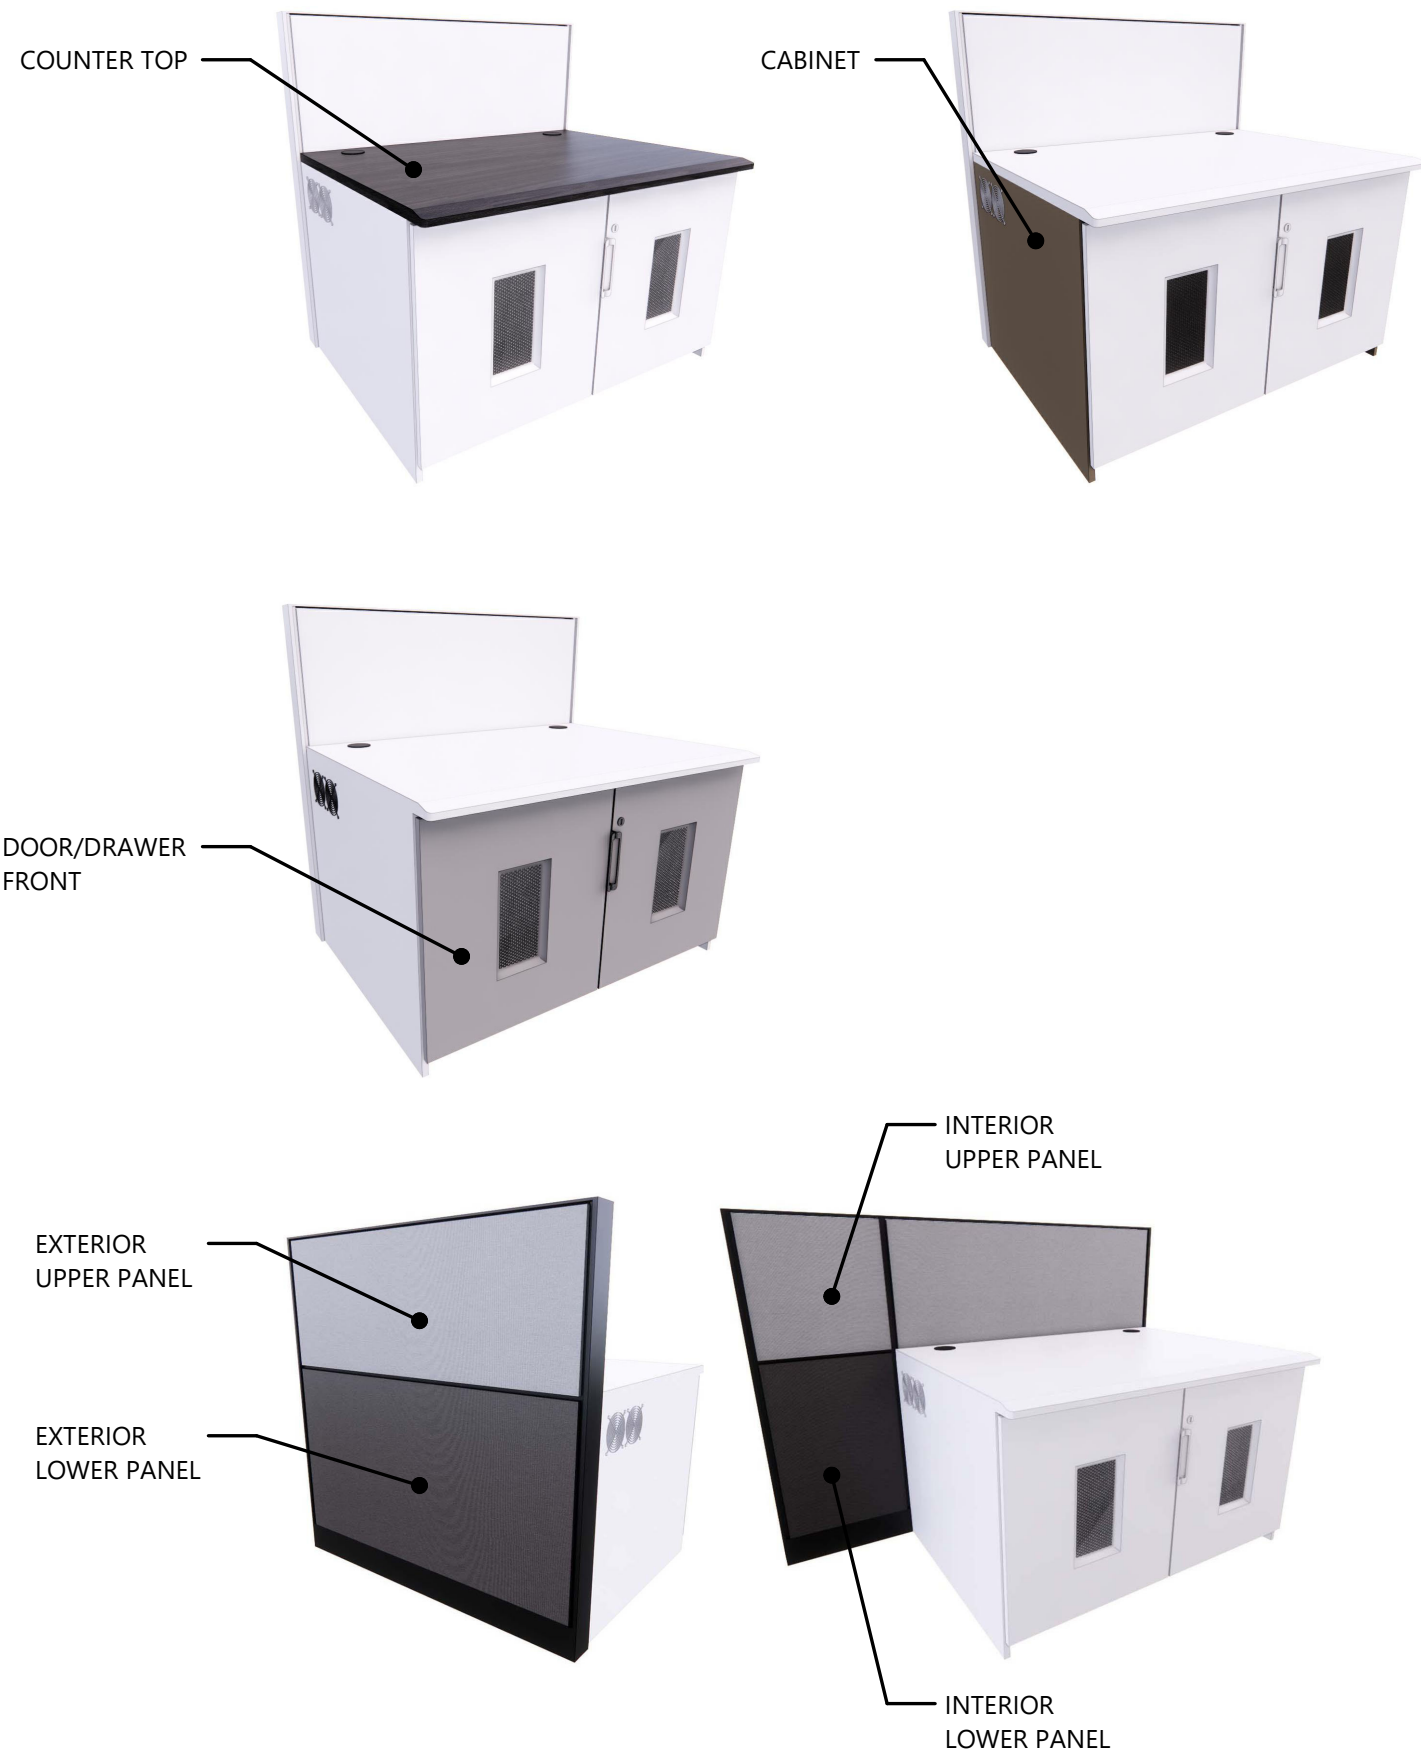




FINISH SELECTIONS

Panel Trim : Black
 Interior Upper Panel : CF Stinson Binary Graphite BIN57
 Interior Lower Panel : CF Stinson Binary Graphite BIN57
 Exterior Upper Panel : .N/A
 Exterior Lower Panel : .N/A
 Counter Top : Dackor Sahara Stone A020
 Door & Drawer Front : Dackor Riviera Oak, Cassis D100
 Cabinet : Panolam Storm TFL S565
 Edgeband : Panolam Storm TFL match
 Handle : Eagle Silver
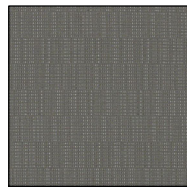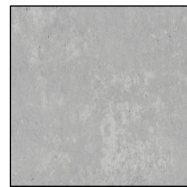
<u>Interior Upper Panel</u>  BINARY GRAPHITE	<u>Exterior Upper Panel</u>  N/A	<u>Counter Top</u>  SAHARA STONE	<u>Handle</u>  SILVER
<u>Interior Lower Panel</u>  BINARY GRAPHITE	<u>Exterior Lower Panel</u>  N/A	<u>Cabinet</u>  STORM	<u>Door/Drawer Front</u>  RIVIERA OAK MISTRAL

CARPET SELECTIONS

Carpet : .N/A
 Cove Base : .N/A
 Installation Method : .N/A
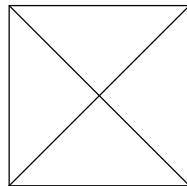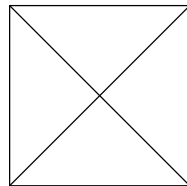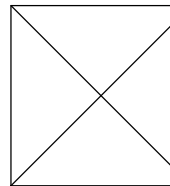
<u>Carpet</u>  N/A	<u>Cove Base</u>  N/A	<u>Installation Method</u>  N/A
---------------------------------------------------------------------------------------------------------------	------------------------------------------------------------------------------------------------------------------	----------------------------------------------------------------------------------------------------------------------------



8207 SouthPark Circle
 Littleton, CO. 80120
 1.800.788.2810 F.303.683.5454
 www.xybix.com

Sales : Amanda Schwartz
 Email : AmandaS@xybix.com
 Designer : Meghan Dinardi
 Email : MeghanD@xybix.com

Lake County Regional 911 Backup Center
 636 Winchester Rd
 Libertyville, IL 60048

Opportunity: 0027369

Carpet Opp: N/A

Drawing Name:
 FINISH SELECTION

SHEET: 10.0 SCALE: 3/8" = 1'-0"

NOTE: This design & layout is the property of XYBIX Systems, Inc. & is not to be used in any written manner without express written permission by XYBIX Systems, Inc.

Sign-Off Initials: _____ REV 3

CABLE EXTENSIONS (PER POSITION)

POSITION(S) TYPE: WS 1-6



8207 SouthPark Circle
Littleton, CO. 80120
1.800.788.2810 F.303.683.5454
www.xybix.com

Sales : Amanda Schwartz
Email : AmandaS@xybix.com
Designer : Meghan Dinardi
Email : MeghanD@xybix.com

Lake County Regional 911 Backup Center
636 Winchester Rd
Libertyville, IL 60048

NO DATADOCK

MONITOR SURFACE CABLES

CABLE TYPE	QUANTITY	CABLE TYPE	QUANTITY
 <u>VGA</u> Male / Female Extension Standard Connection for monitors.		 <u>DVI-D</u> Male / Female Extension Typical for Hi-Resolution	
 <u>DVI-I</u> 10' Max Length Male / Female Extension Typical for Hi-Resolution		 <u>HDMI</u> Male / Male Extension Typical for Hi-Resolution	
 <u>Display Port</u> Male / Male Extension Typical for Hi-Resolution	4 EA.	 <u>Display Port to Mini Display Port</u>	
 <u>USB</u>			
 <u>AUDIO</u> Typical for Speakers		OPTIONAL ITEMS FOR MONITOR SURFACE (EX: CABLE ADAPTORS, USB'S)	
CABLE ADAPTOR TYPE	QUANTITY	_____	_____
		TO	TO
		_____	_____
CABLE ADAPTOR TYPE	QUANTITY		

Opportunity: 0027369
Carpet Opp: N/A
Drawing Name:
CABLE SHEET

SHEET: 11.0
SCALE:

NOTE: This design & layout is the property of XYBIX Systems, Inc. & is not to be used in any written manner without express written permission by XYBIX Systems, Inc.

If different cable connector types are required it is your responsibility to contact your Designer or Sales Rep. You agree that any changes to this order following receipt of sign-off drawing and PO may result in additional cost that will be expensed to the client.

Signature: _____

Date: _____

Sign-Off Initials: _____
REV
3